


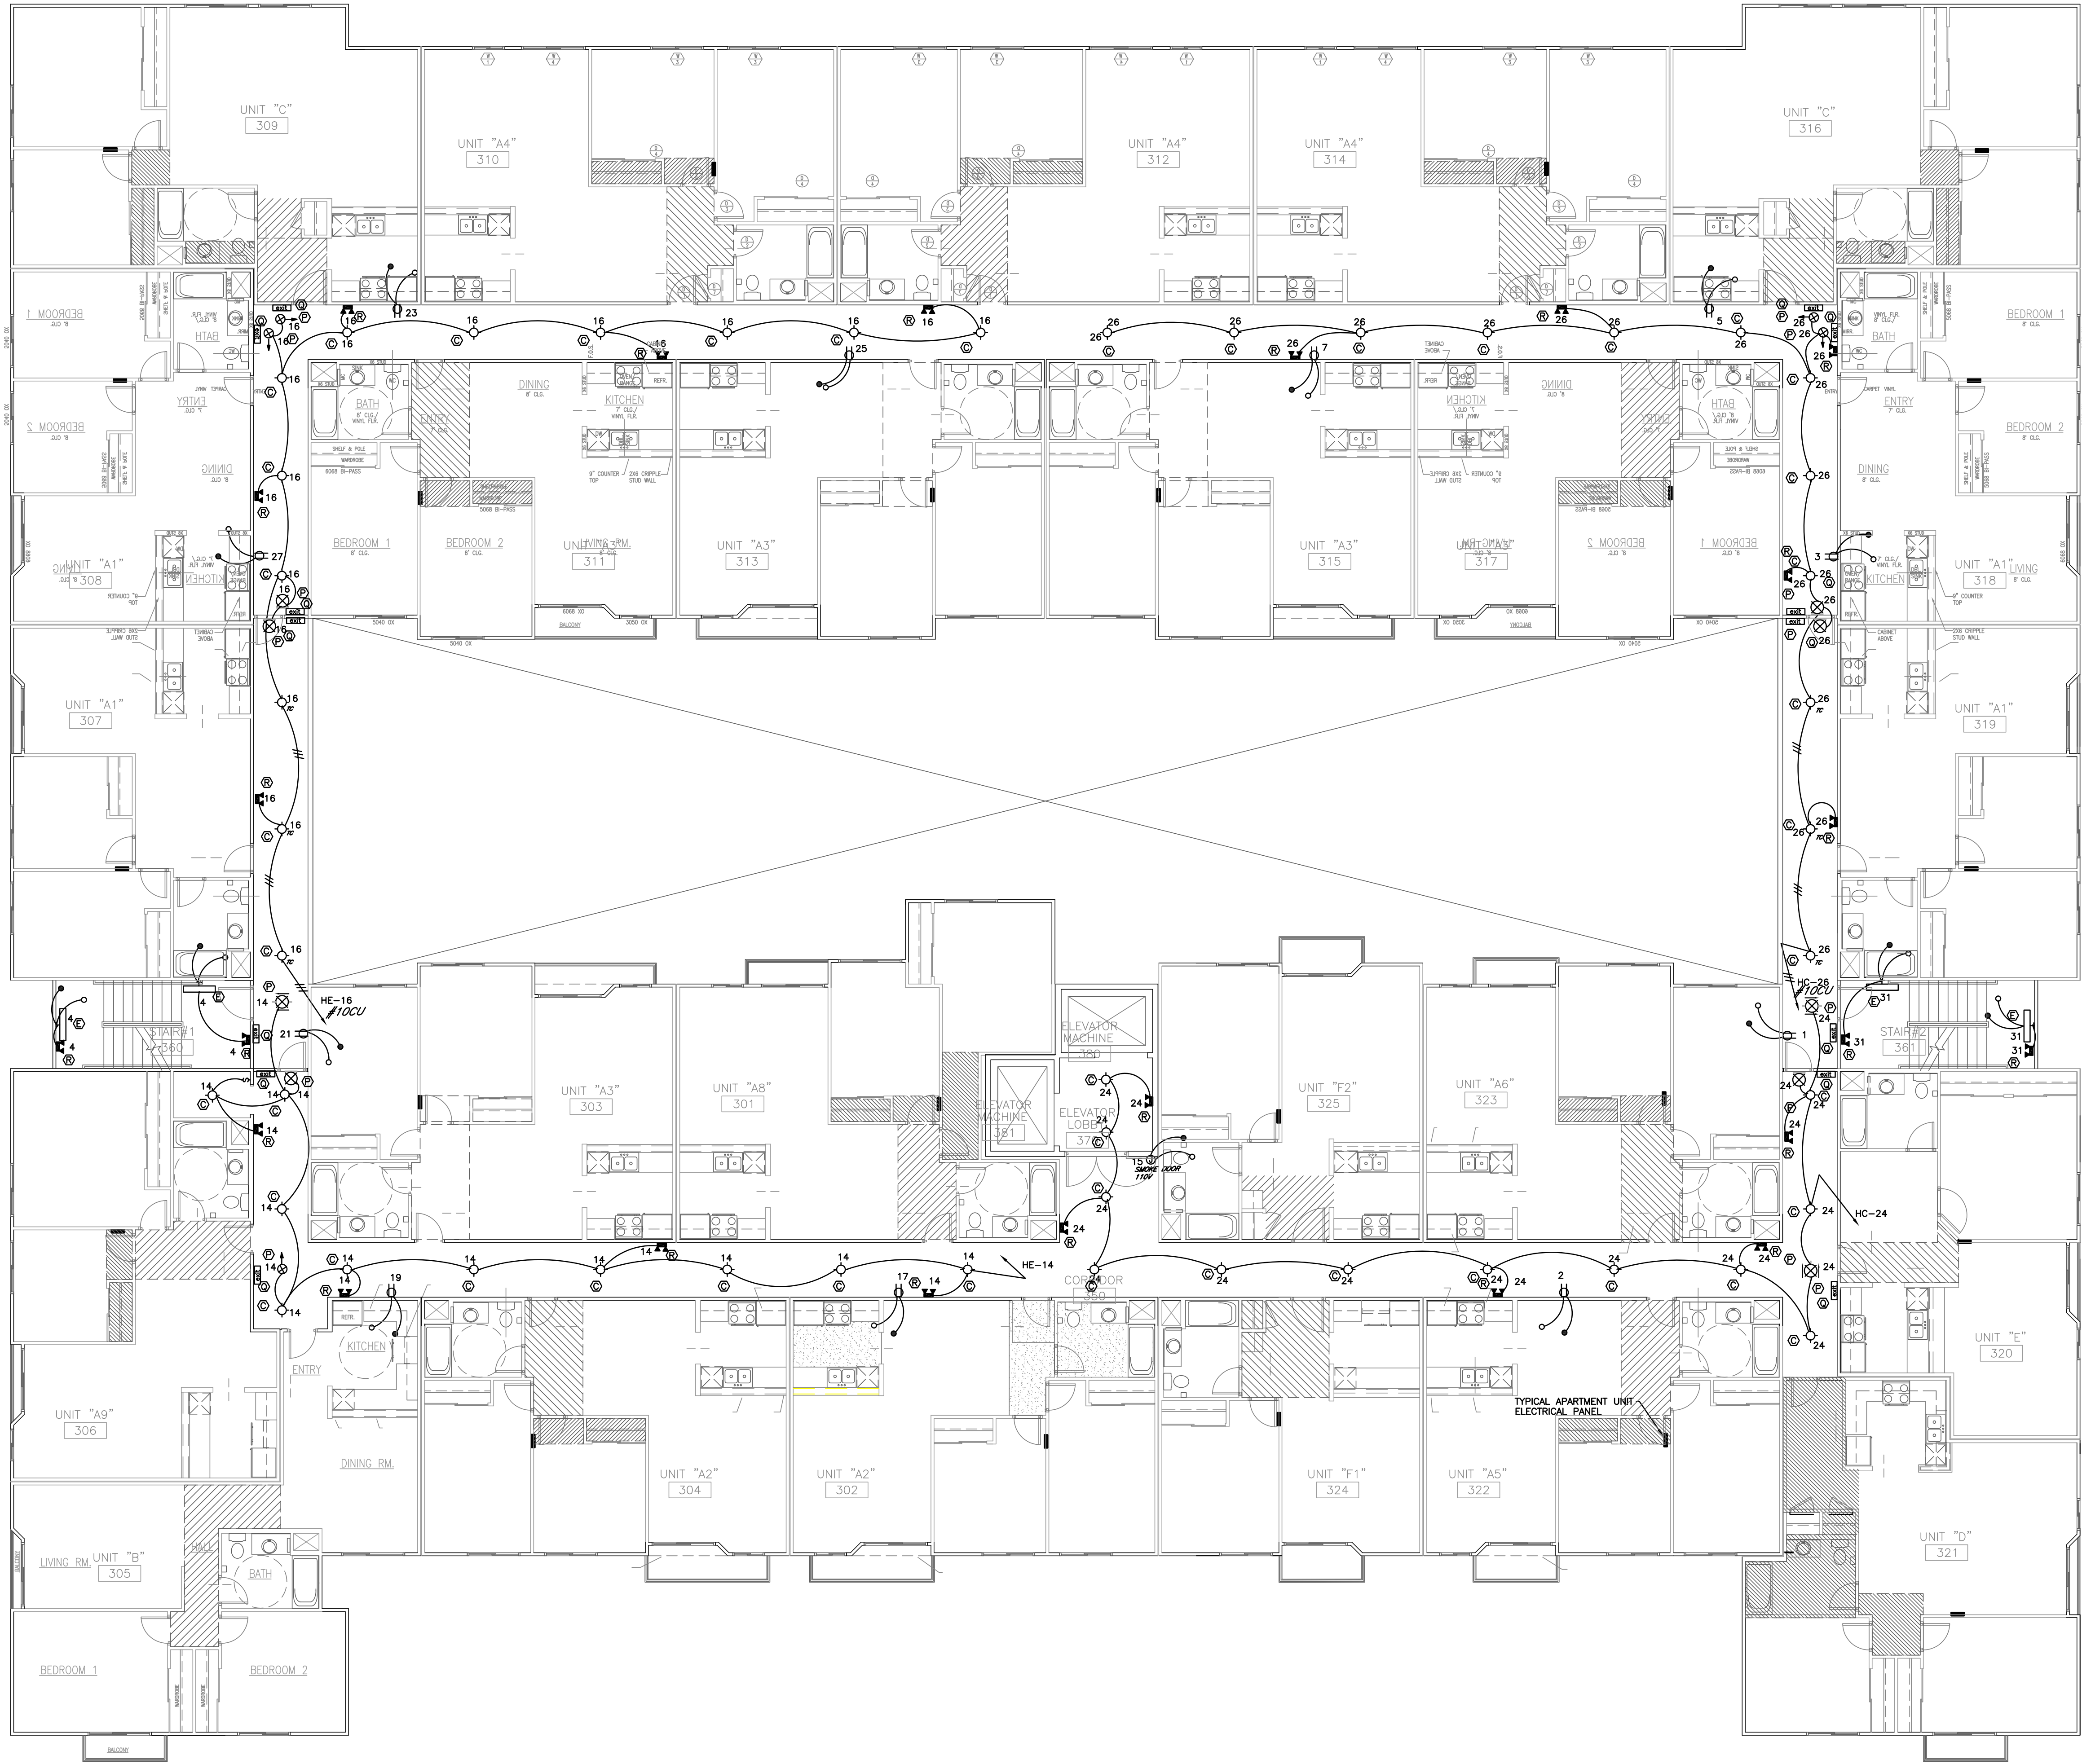

SATICOY STREET

THIRD FLOOR PLAN

SCALE: 1/8"=1'-0"



FINAL PLAN CHECK / FOR CONSTRUCTION 5-4-06

F-7

OF 14 SHEETS

DATE: 1-24-05

JOE # 5802

91 UNIT
APARTMENT PROJECT
20237 W. SATICOY STREET
WINNETKA, CALIFORNIA

THIRD FLOOR PLAN

JOHN R. HANZLIK & ASSOC., INC.
CONSULTING ELECTRICAL ENGINEERING

7100 WARDENBURG AVE. SUITE 301
VAN NUYS, CA 91411-3804
TEL: 818-901-1778 FAX: 818-901-1962
WWW.JRHANZLIK.COM

CLIENT: SATICOY INVESTMENT PROPERTIES

DATE: .