


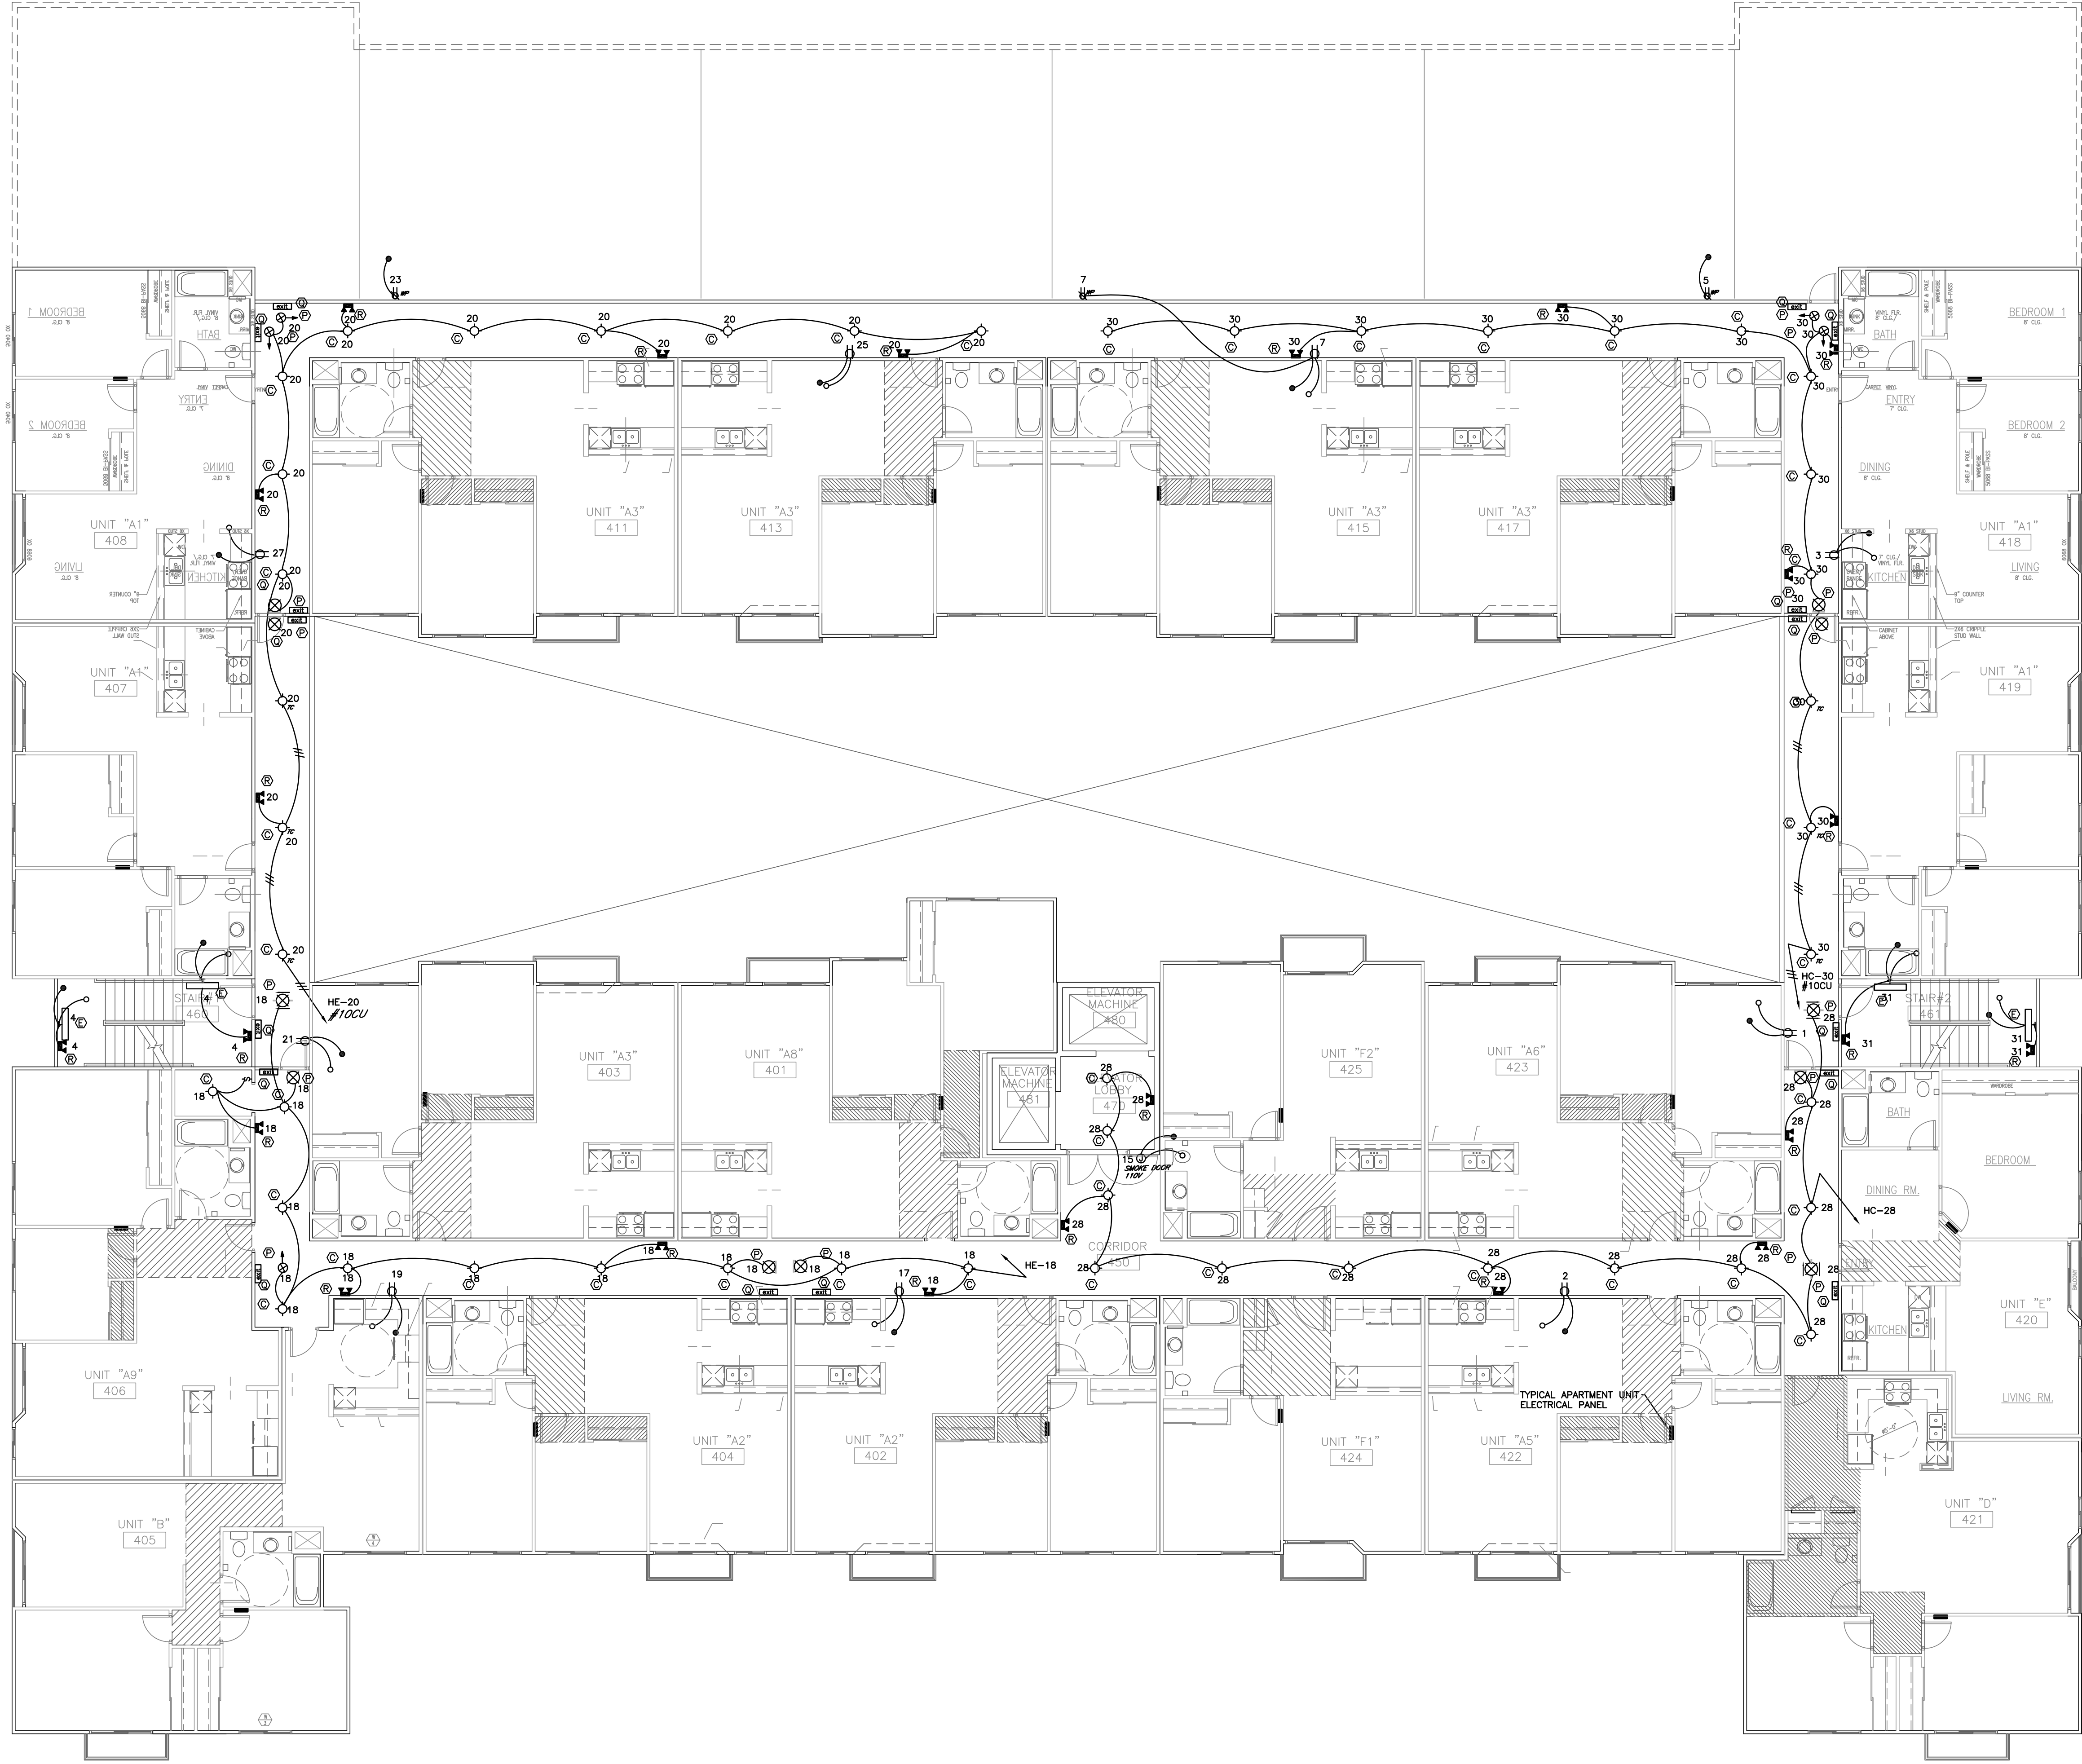

SATICOY STREET

FOURTH FLOOR PLAN

SCALE: 1/8"=1'-0"



FINAL PLAN CHECK / FOR CONSTRUCTION 5-4-06

91 UNIT
APARTMENT PROJECT
20237 W. SATICOY STREET
WINNETKA, CALIFORNIA
FOURTH FLOOR PLAN

DATE: 1-24-05
SHEET # 5802
OF 14 SHEETS

JOHN R. HANZLIK & ASSOC., INC.
CONSULTING ELECTRICAL ENGINEERING
7100 WILSHIRE AVE. SUITE 301
VAN NUYS, CA 91408-1804
TEL: 818-901-1775 FAX: 818-901-1962
WWW.HANZLIK-ASSOC.COM

CLIENT: SATICOY INVESTMENT PROPERTIES

DATE	BY	CHKD	APPD