
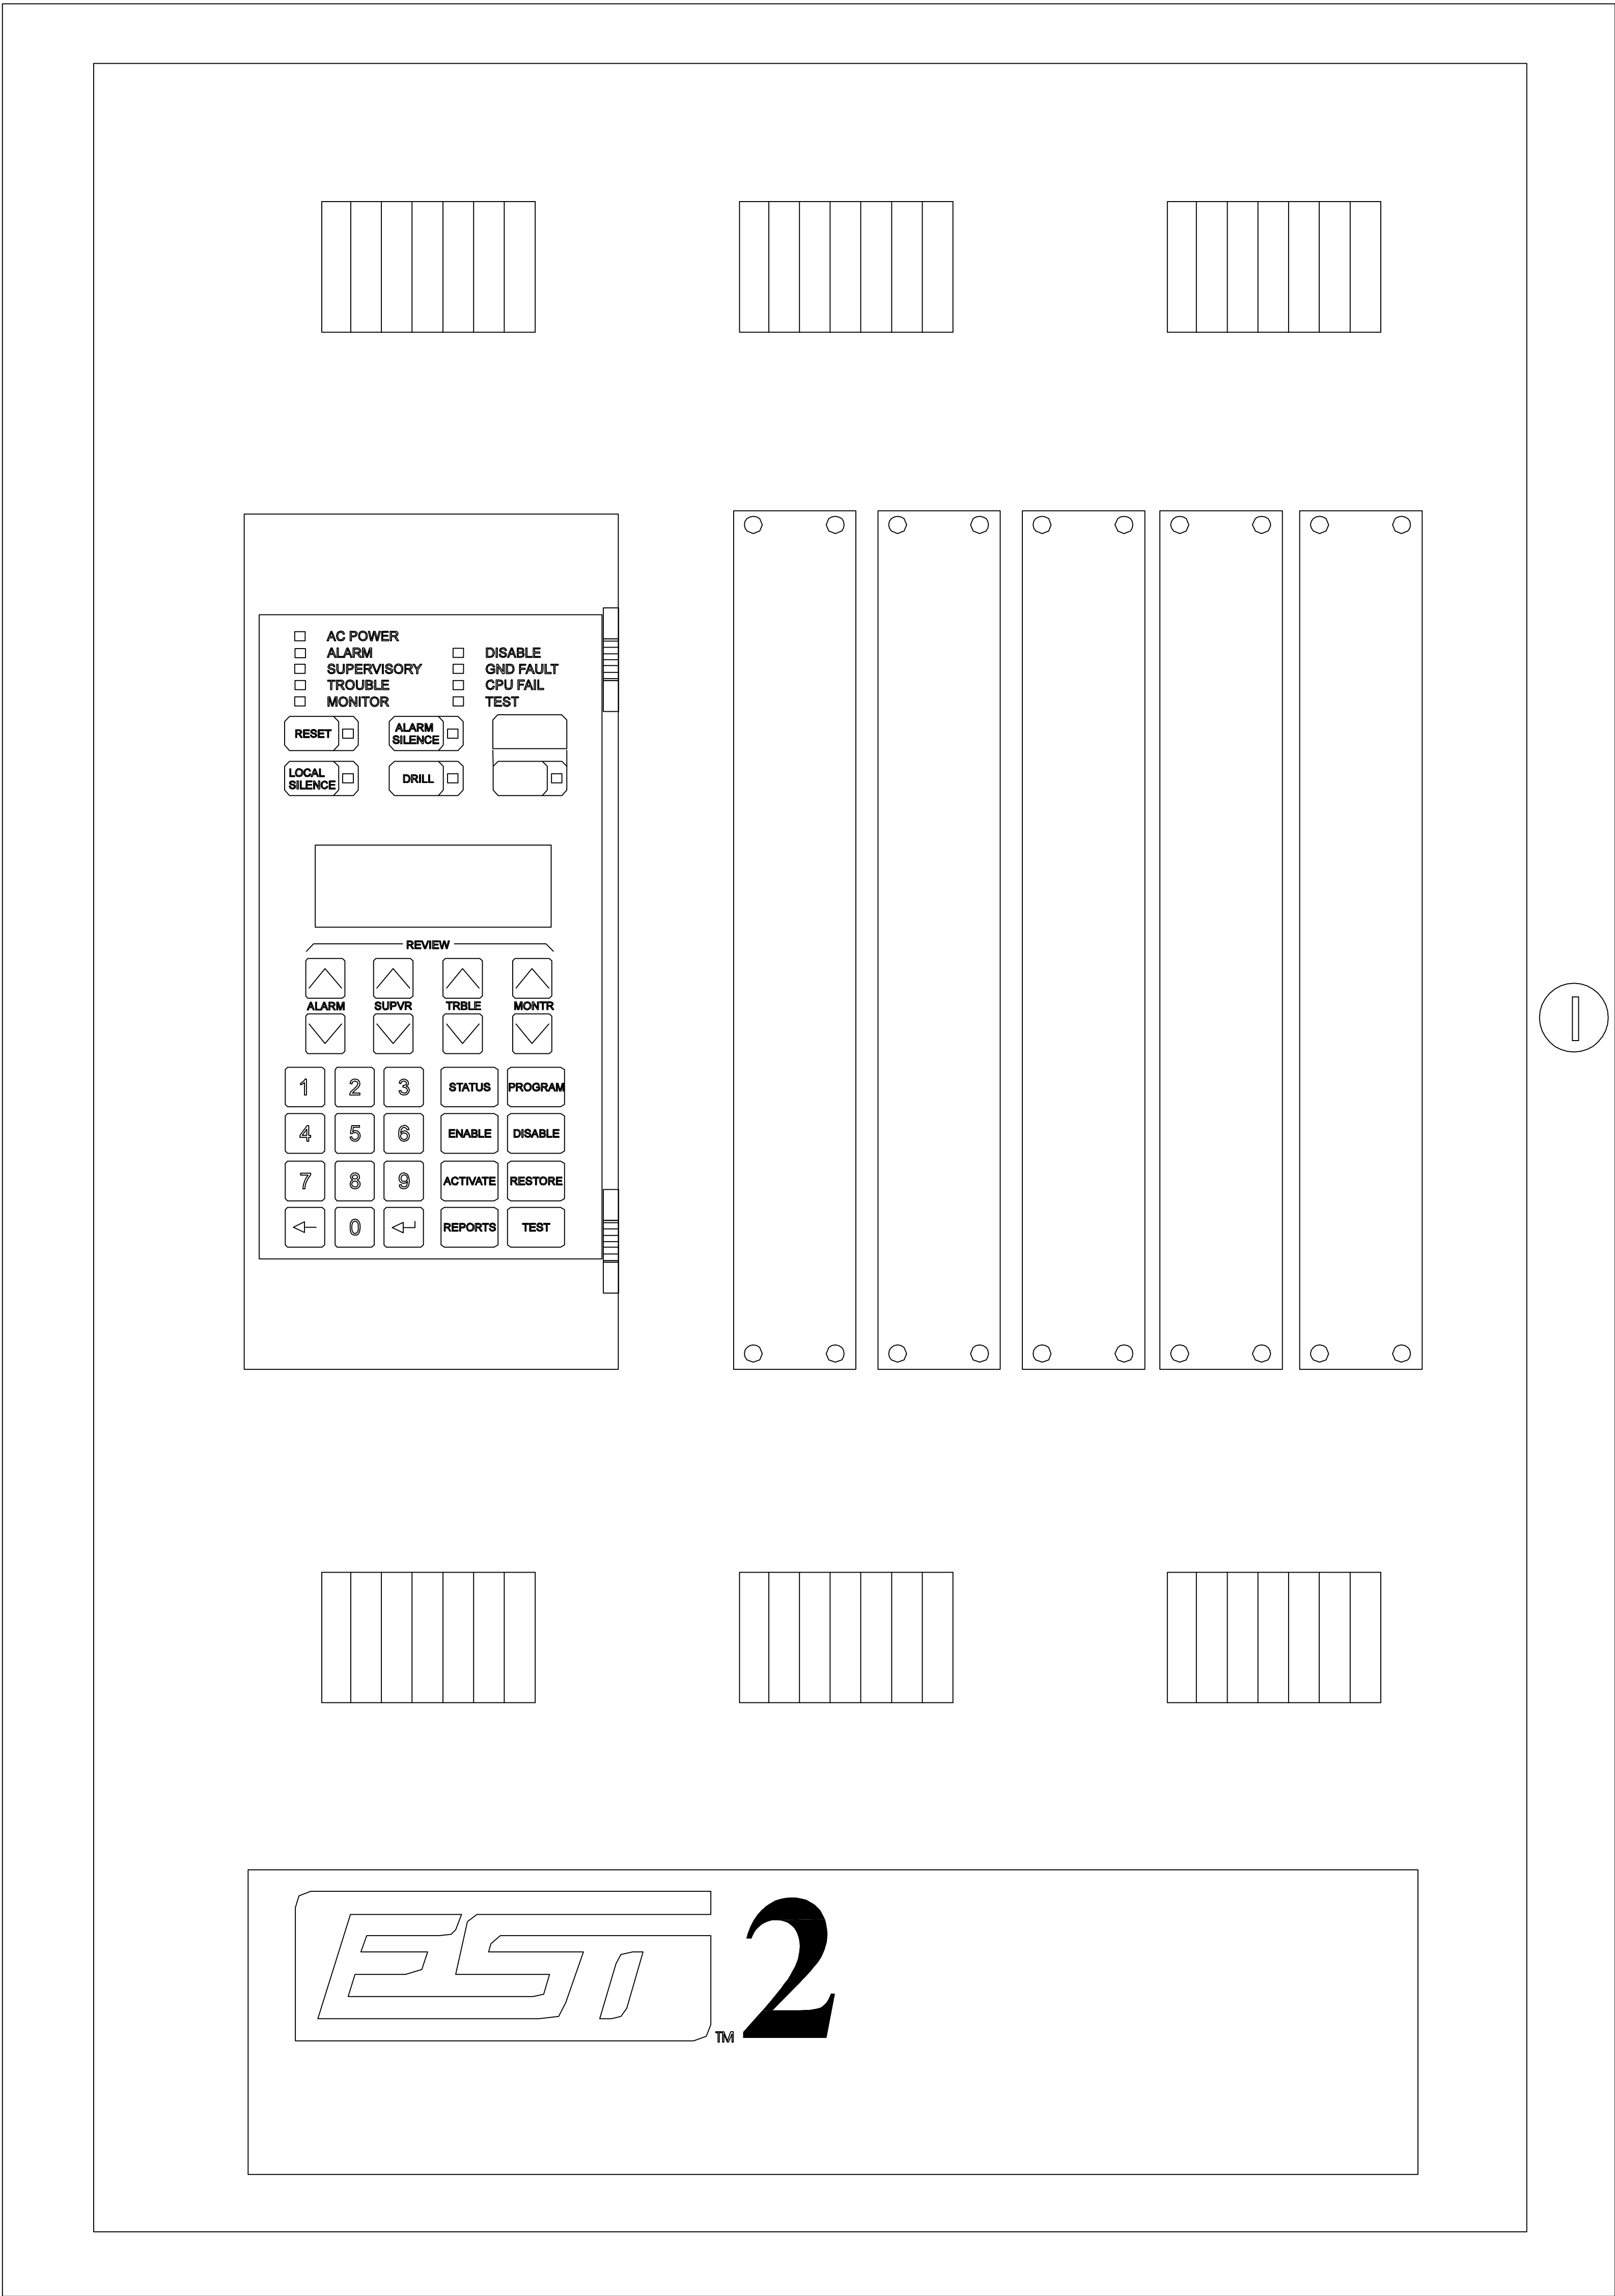


FIRE ALARM PANEL

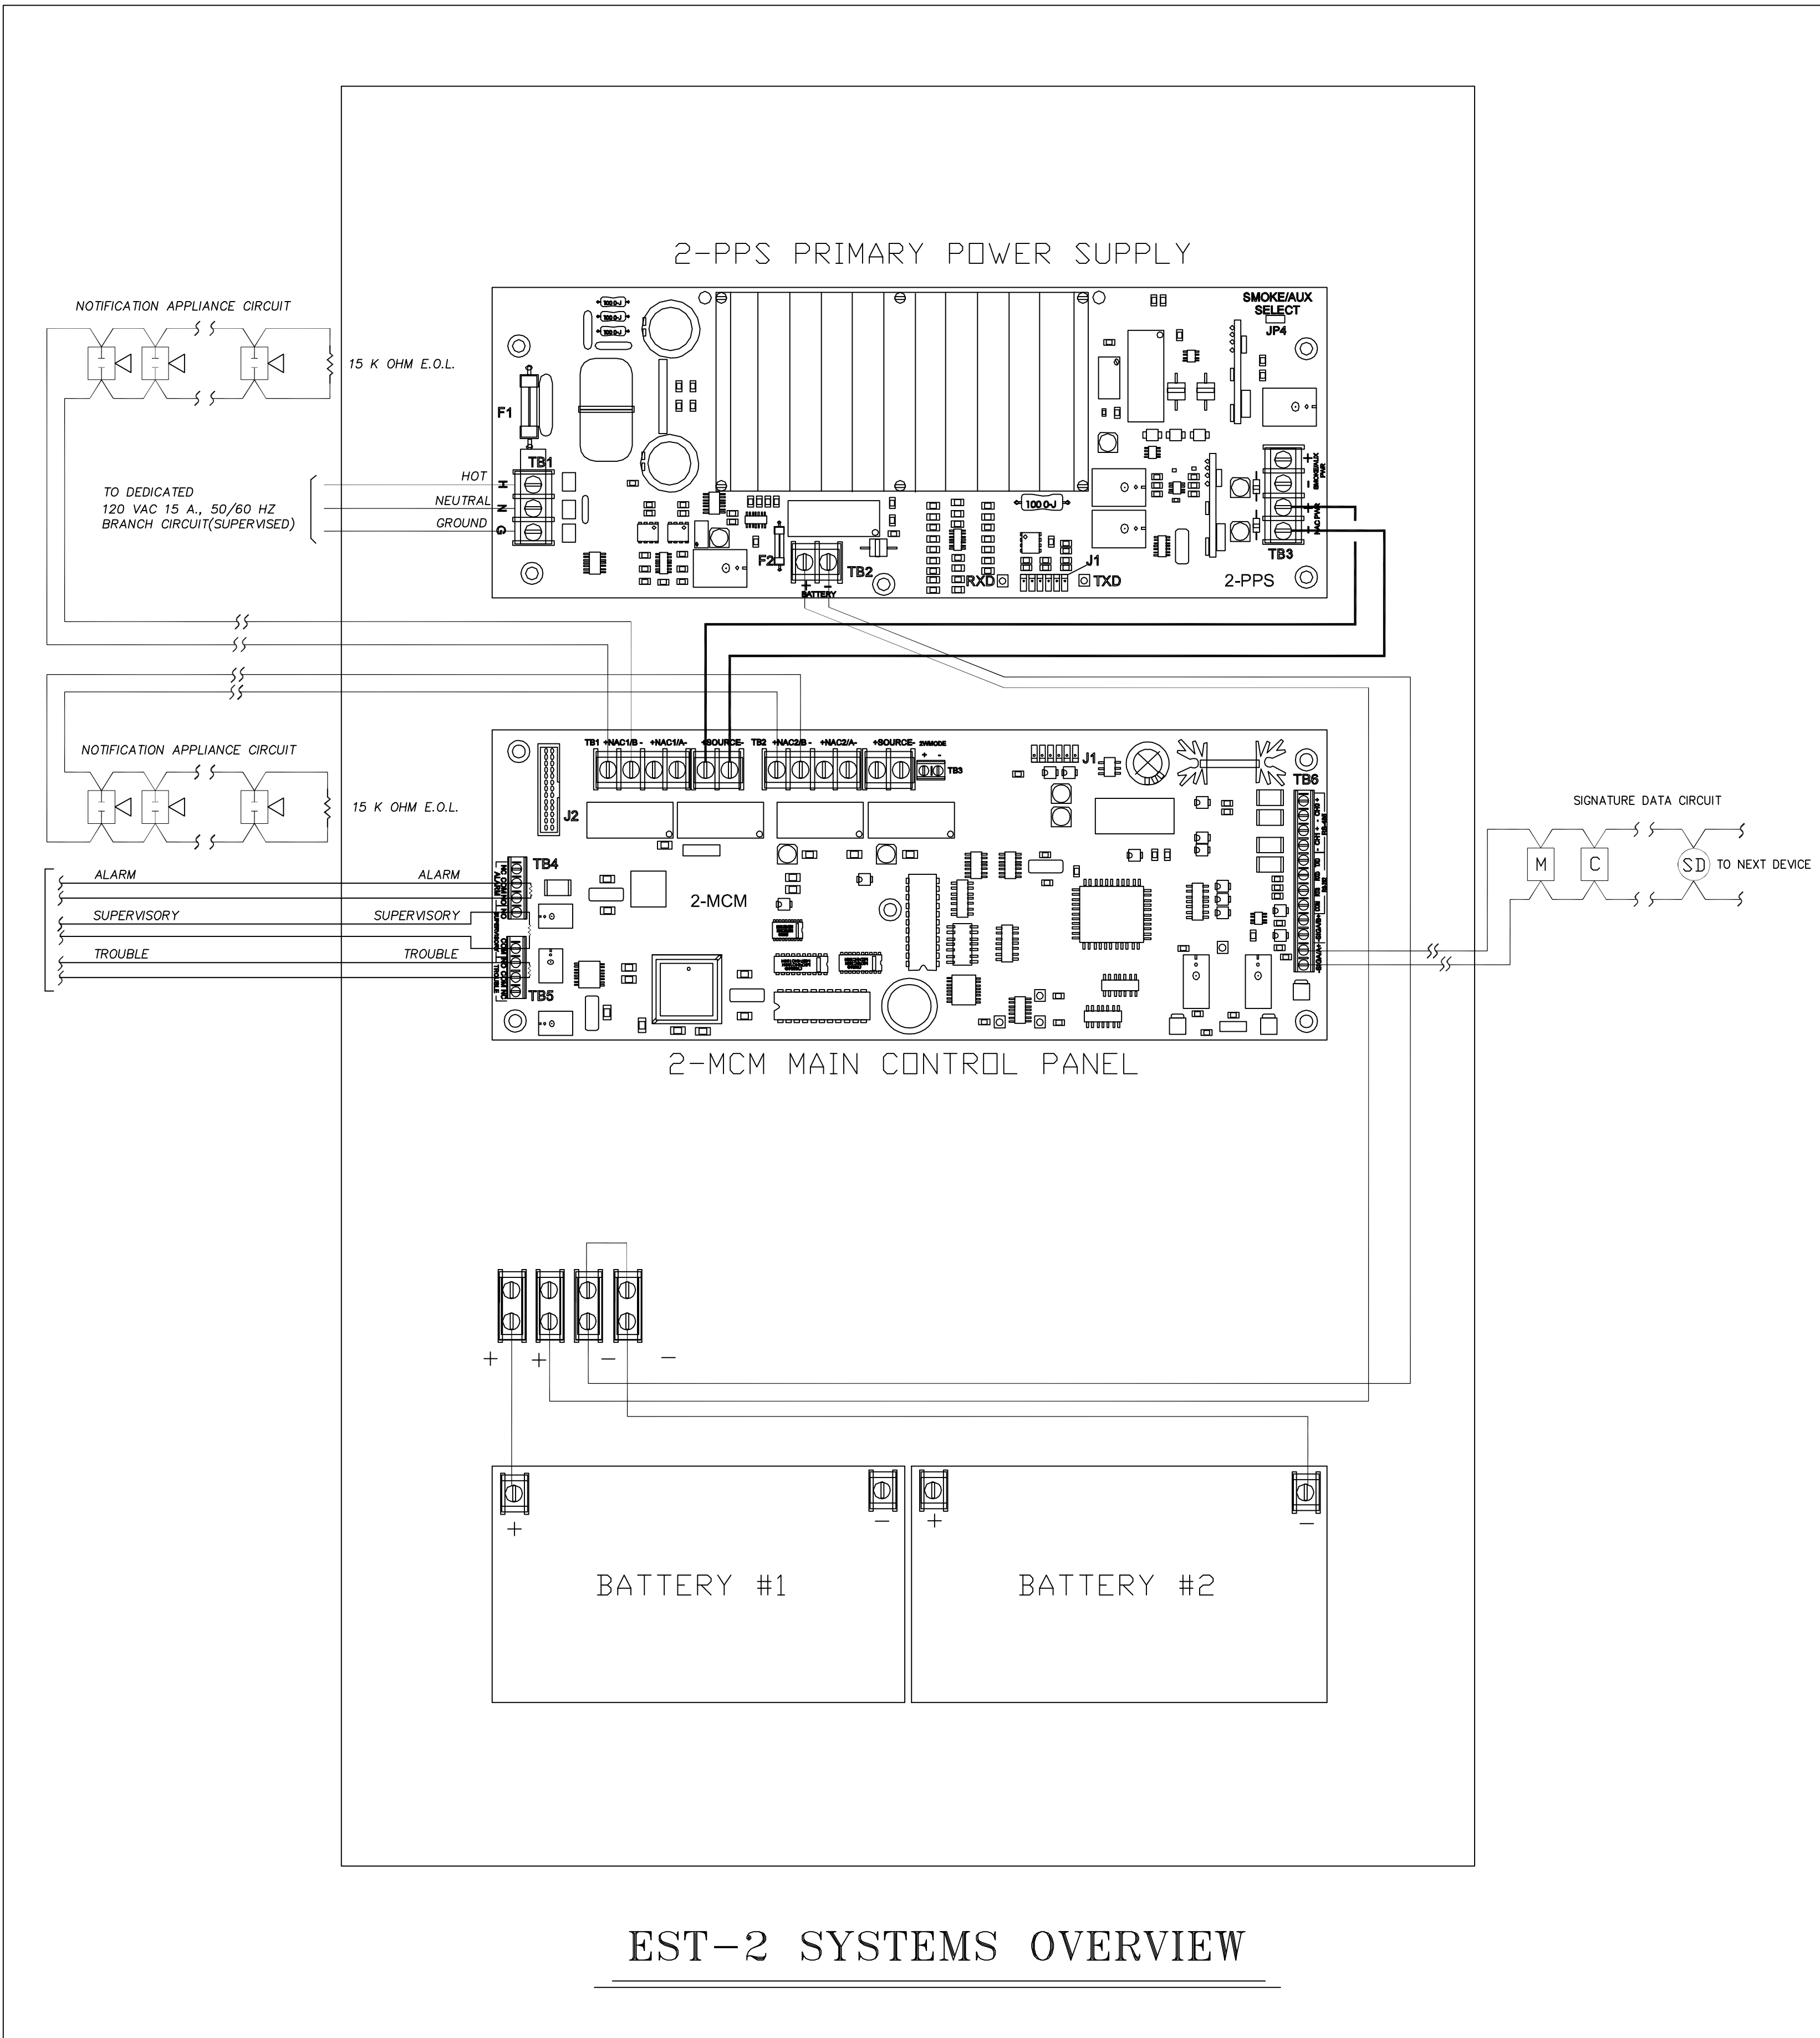

**ALARM ENGINEERS**  
11145 TAMPA AVE. SUITE #24B  
NORTH RIDGE, CA. 91326  
TEL. (818) 831-5390 FAX. (818) 831-5391 LIC. # C10 867596

Project:  
**91 UNITS APARTMENT BUILDING**  
20223-20237 W. SATICOY STREET  
WINNETKA, CALIFORNIA 91306

| Revisions |        |               |
|-----------|--------|---------------|
| No.       | Date   | Description   |
| 1         | 5/5/06 | FIRST RELEASE |
|           |        |               |
|           |        |               |
|           |        |               |
|           |        |               |

Sheet Title:  
**FIRE ALARM SYSTEM**  
FIRE ALARM CONTROL  
PANEL DETAILS

Sheet Number:  
**FA-02**