
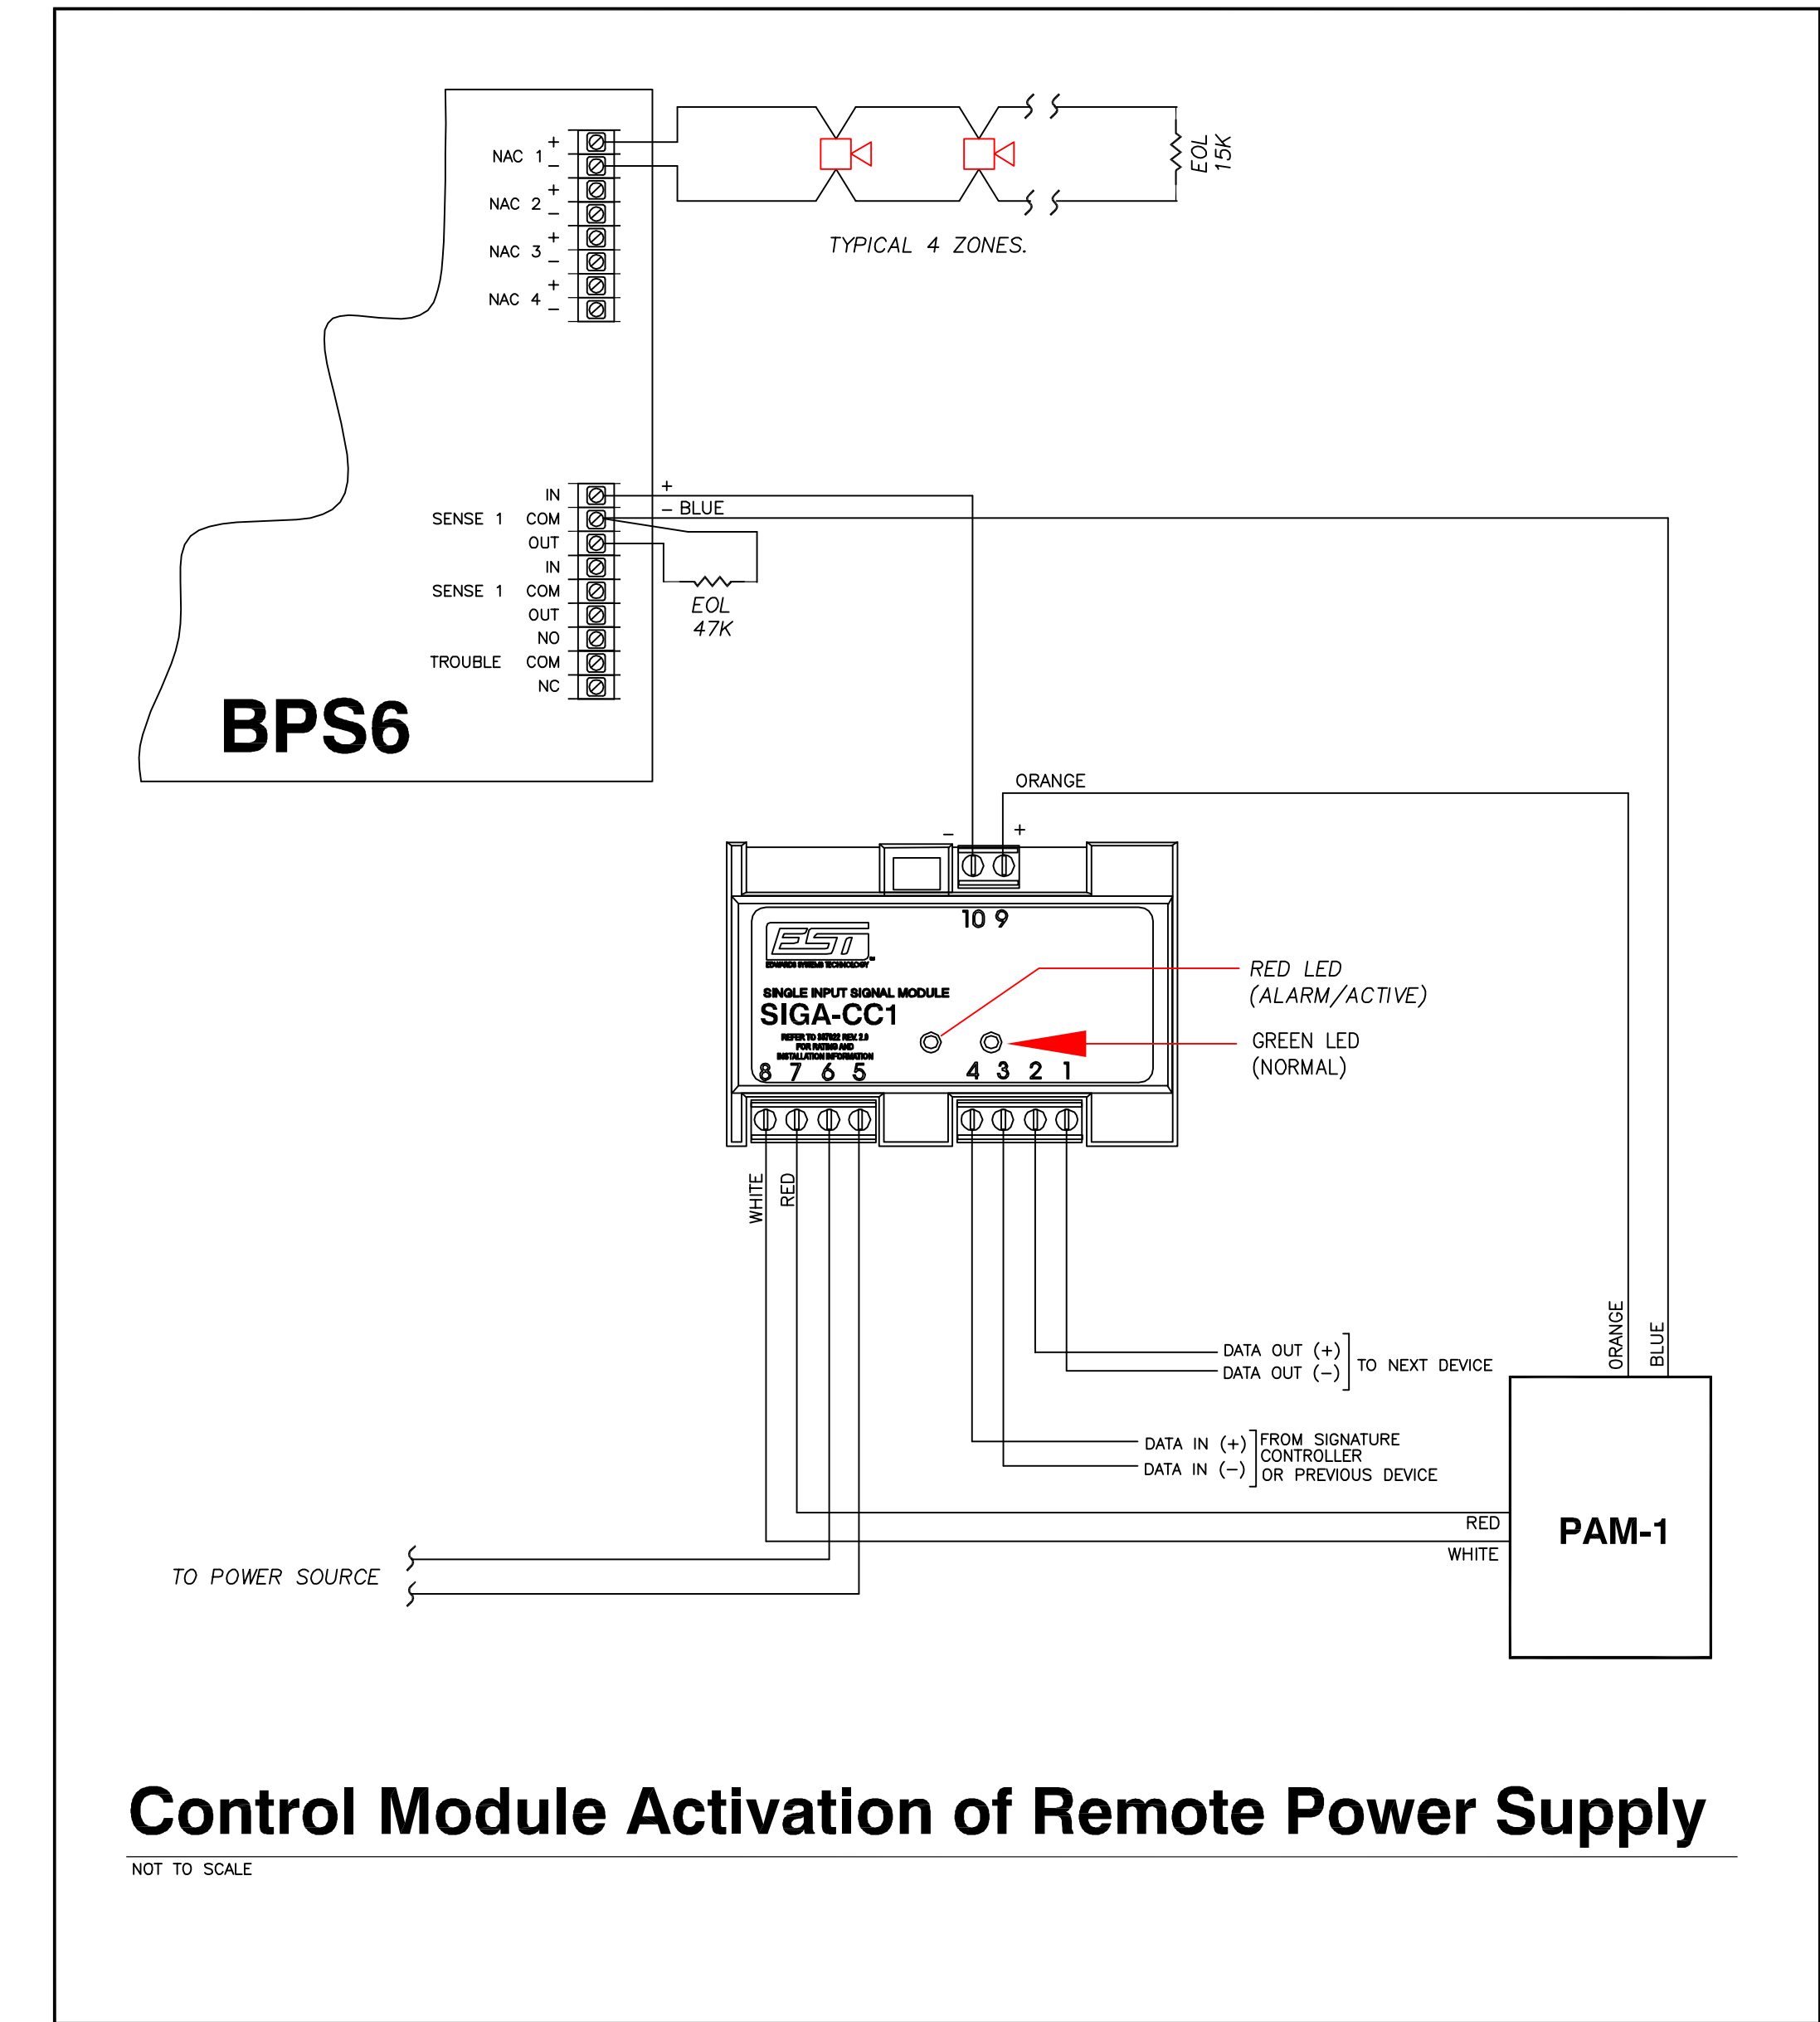
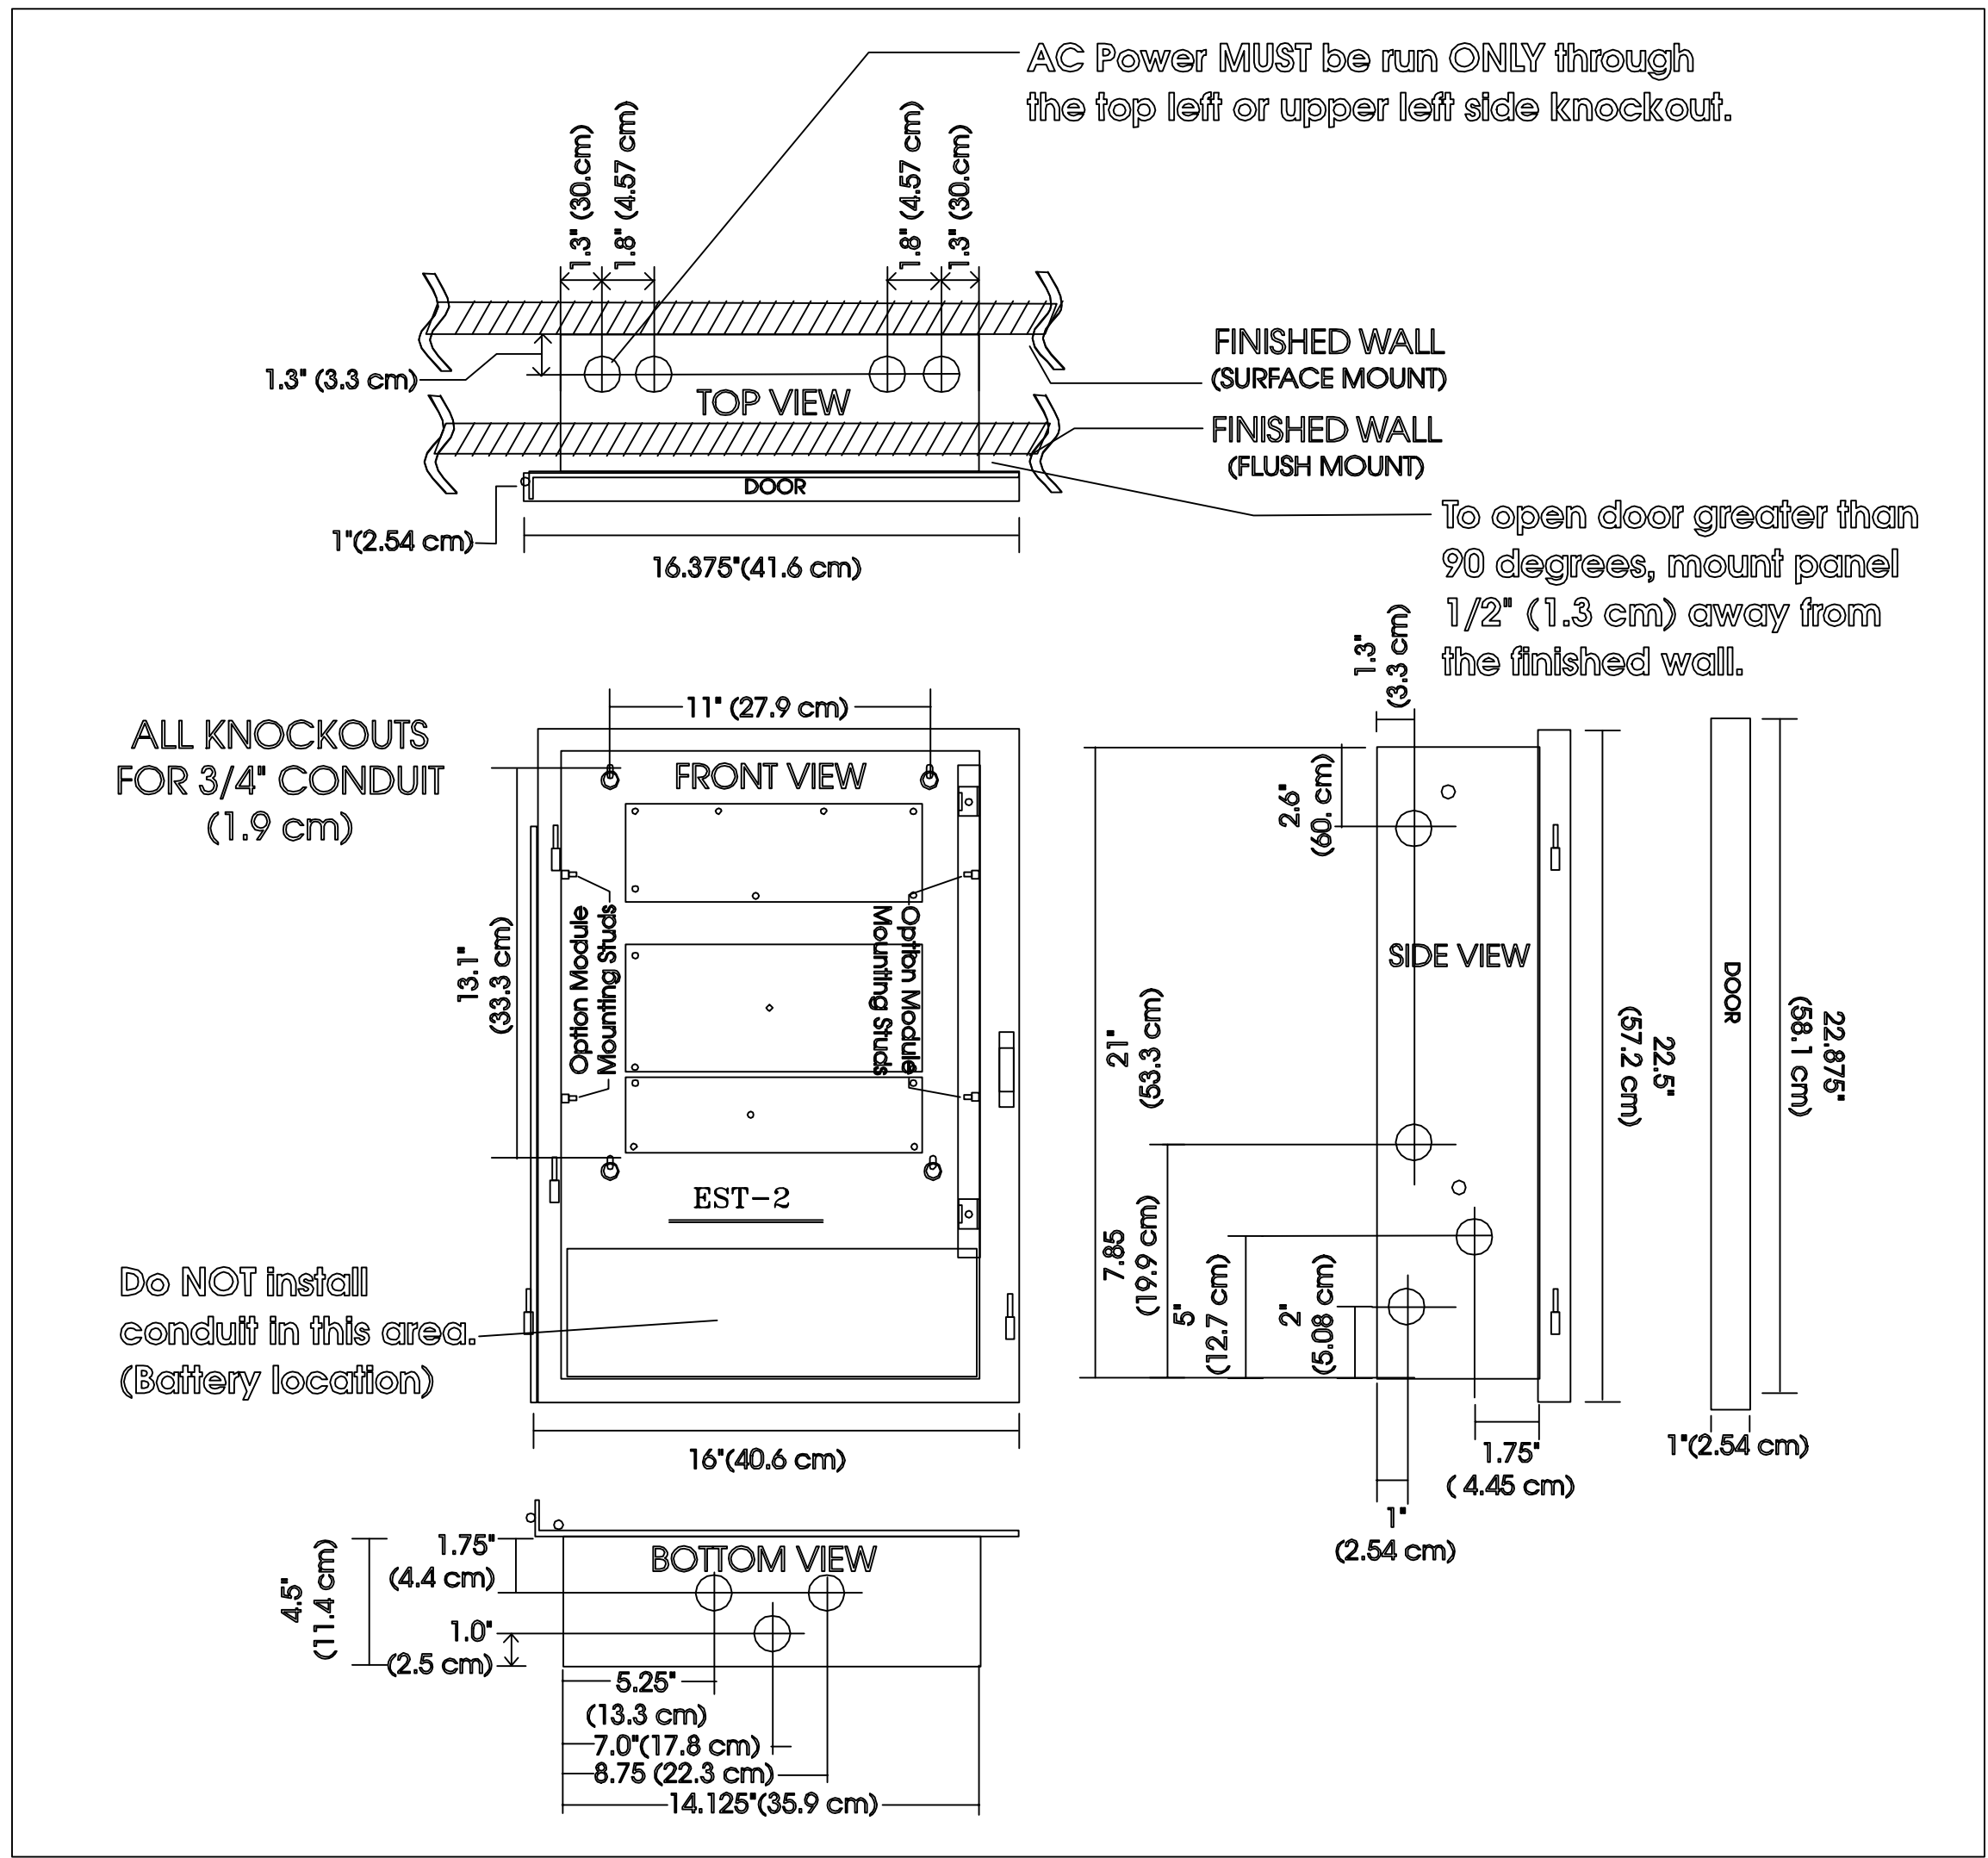
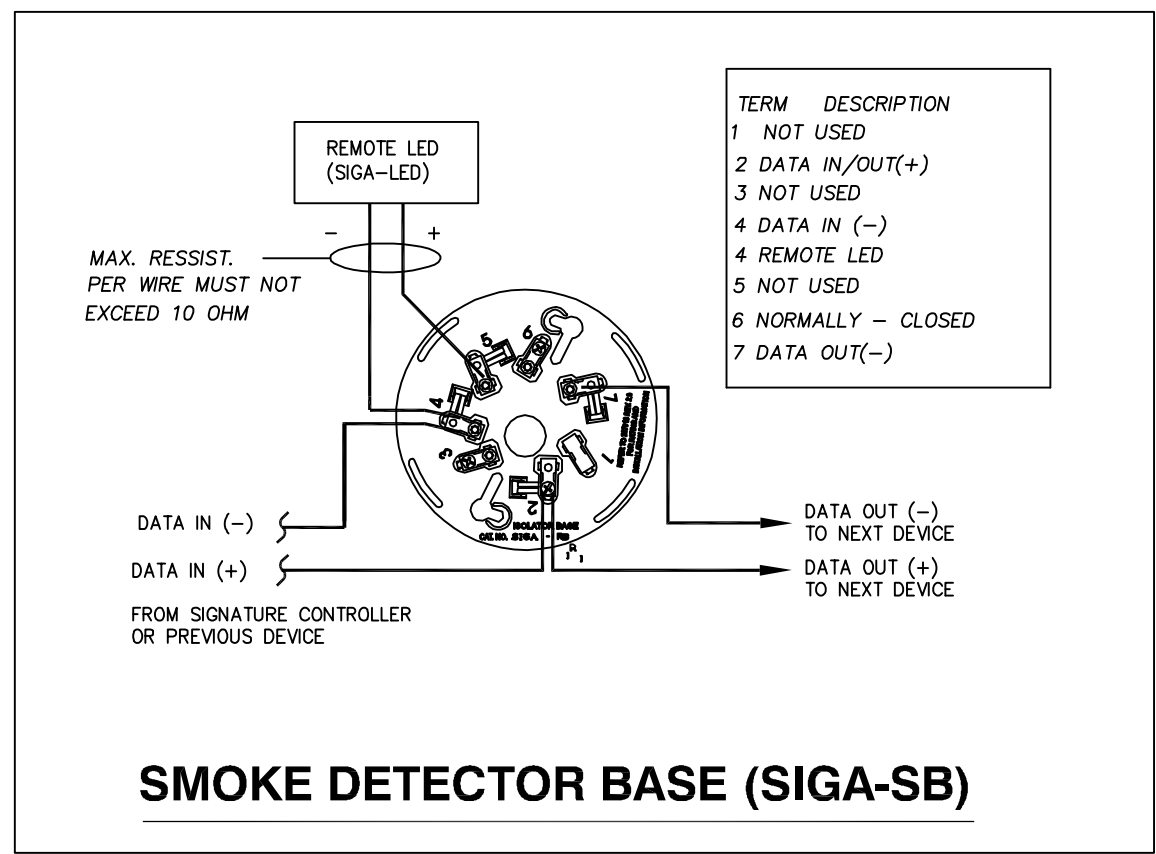
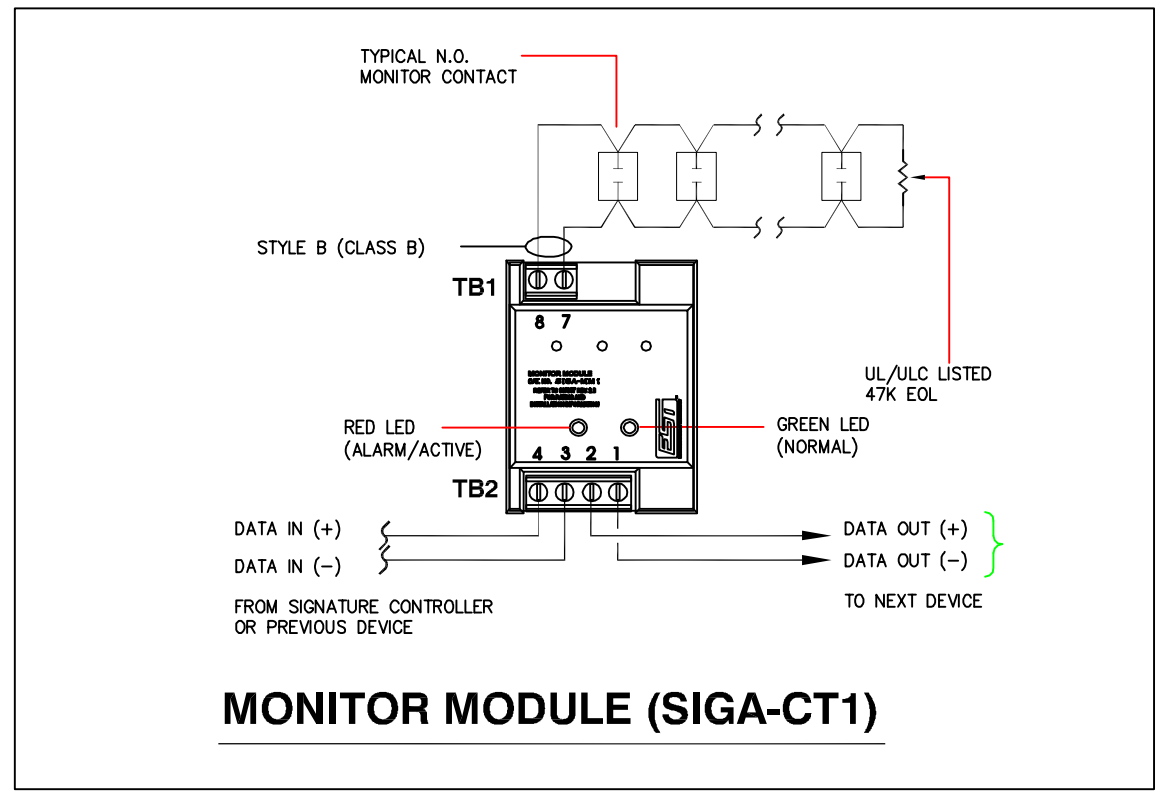
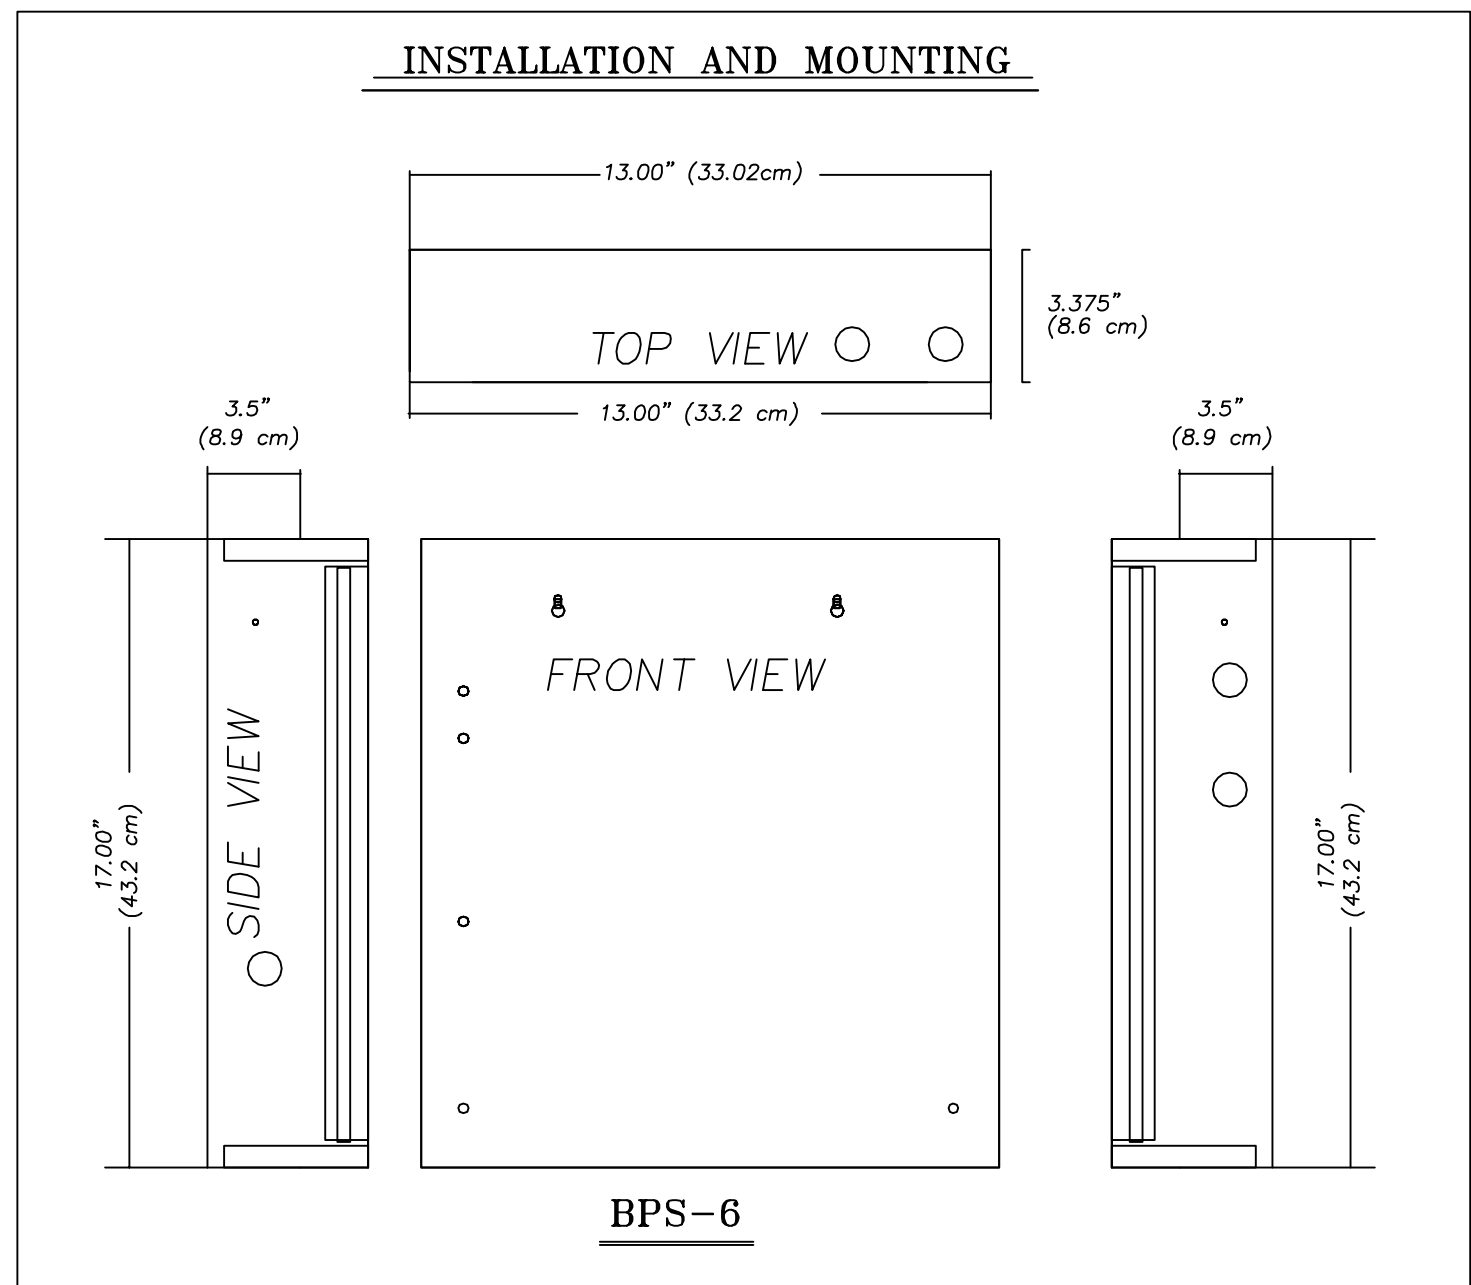
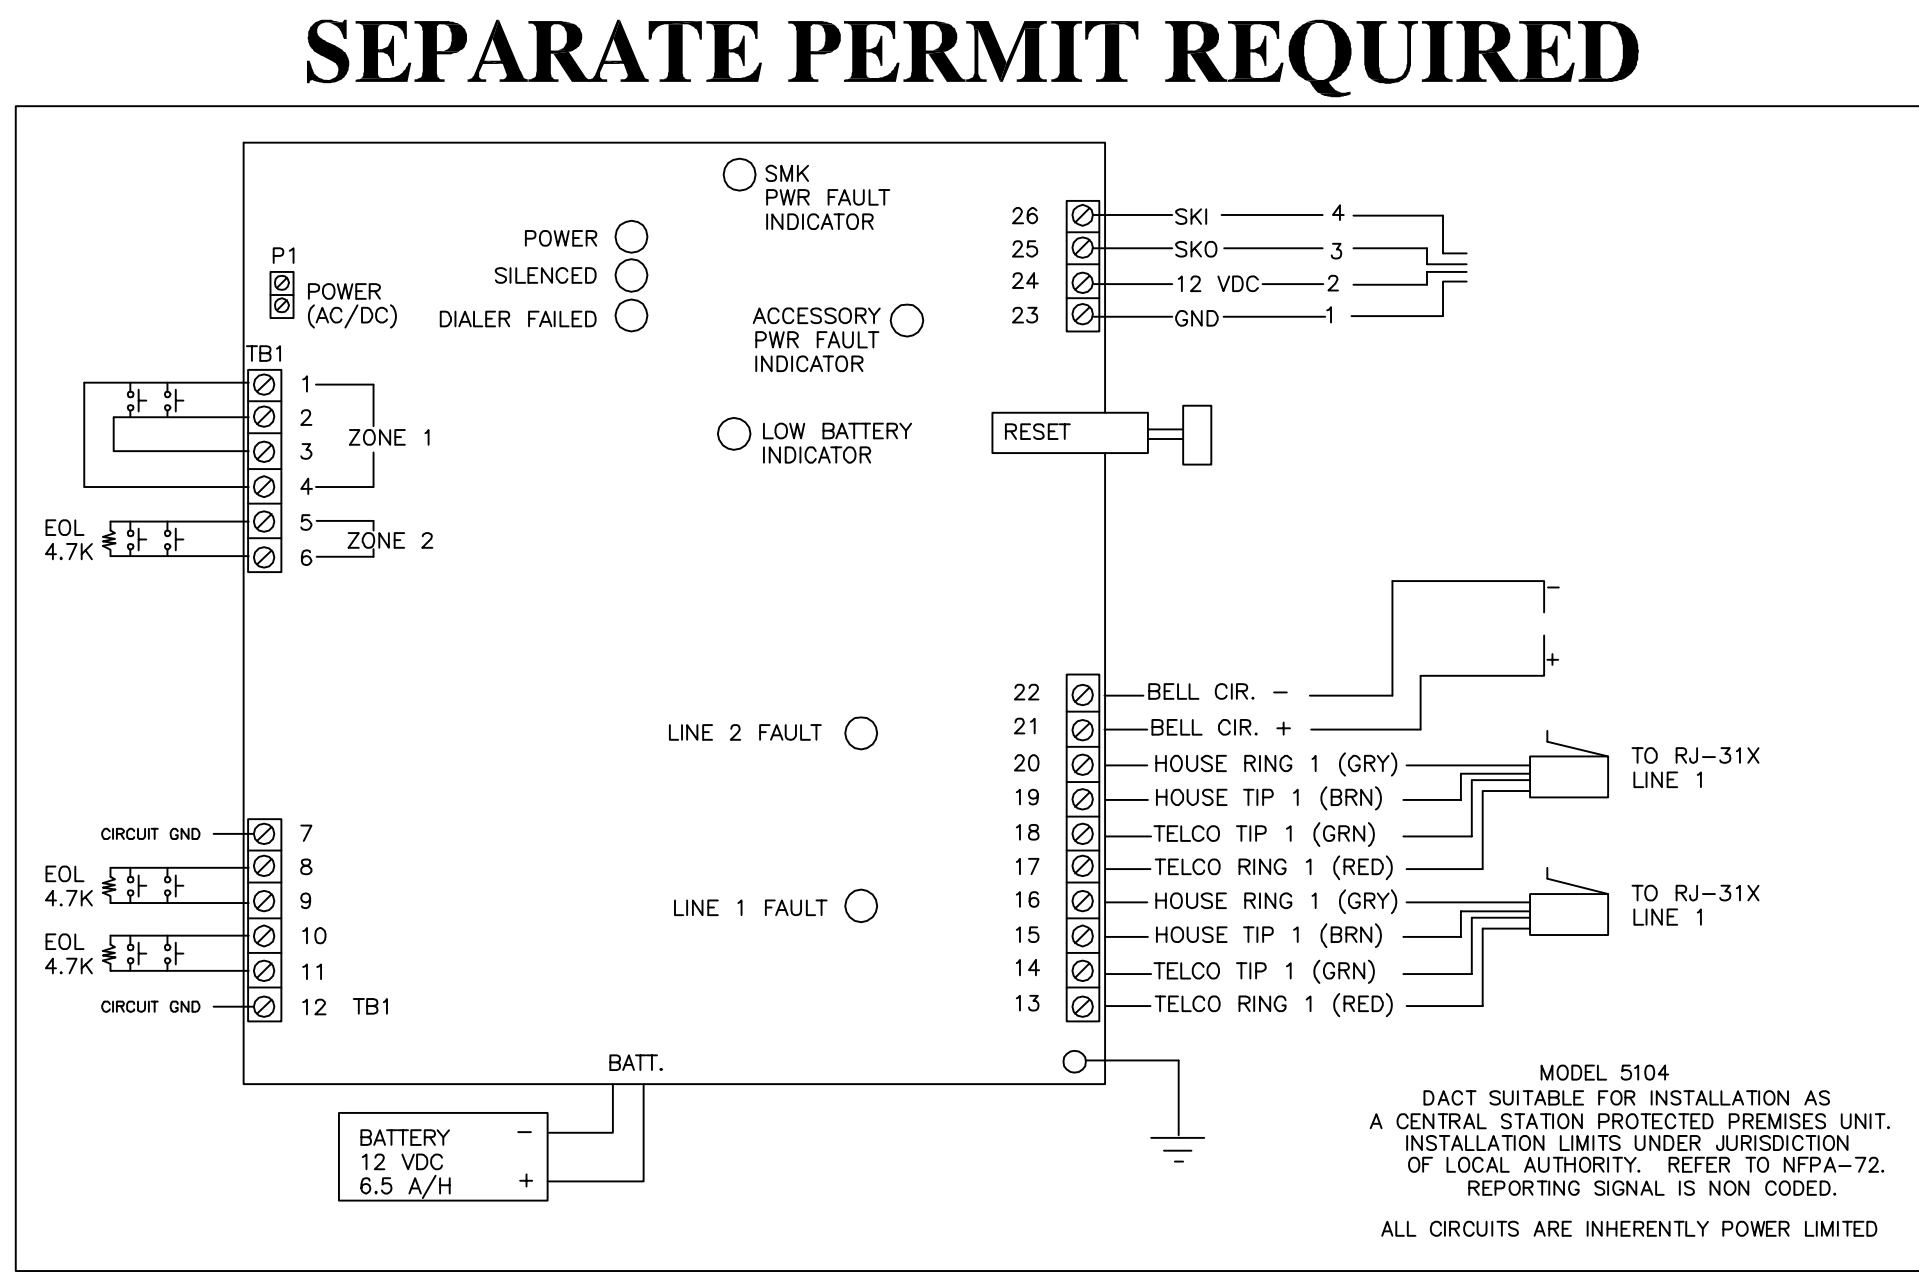
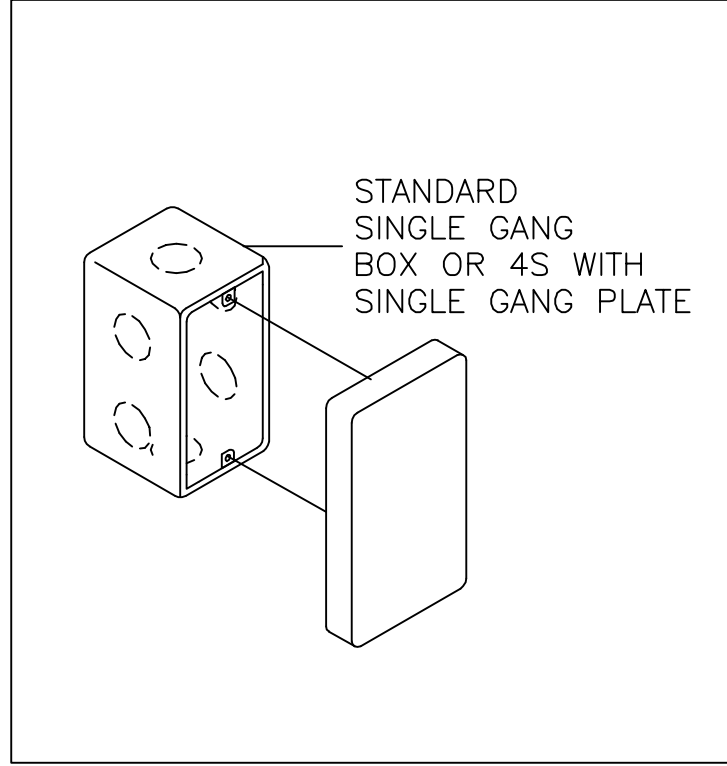
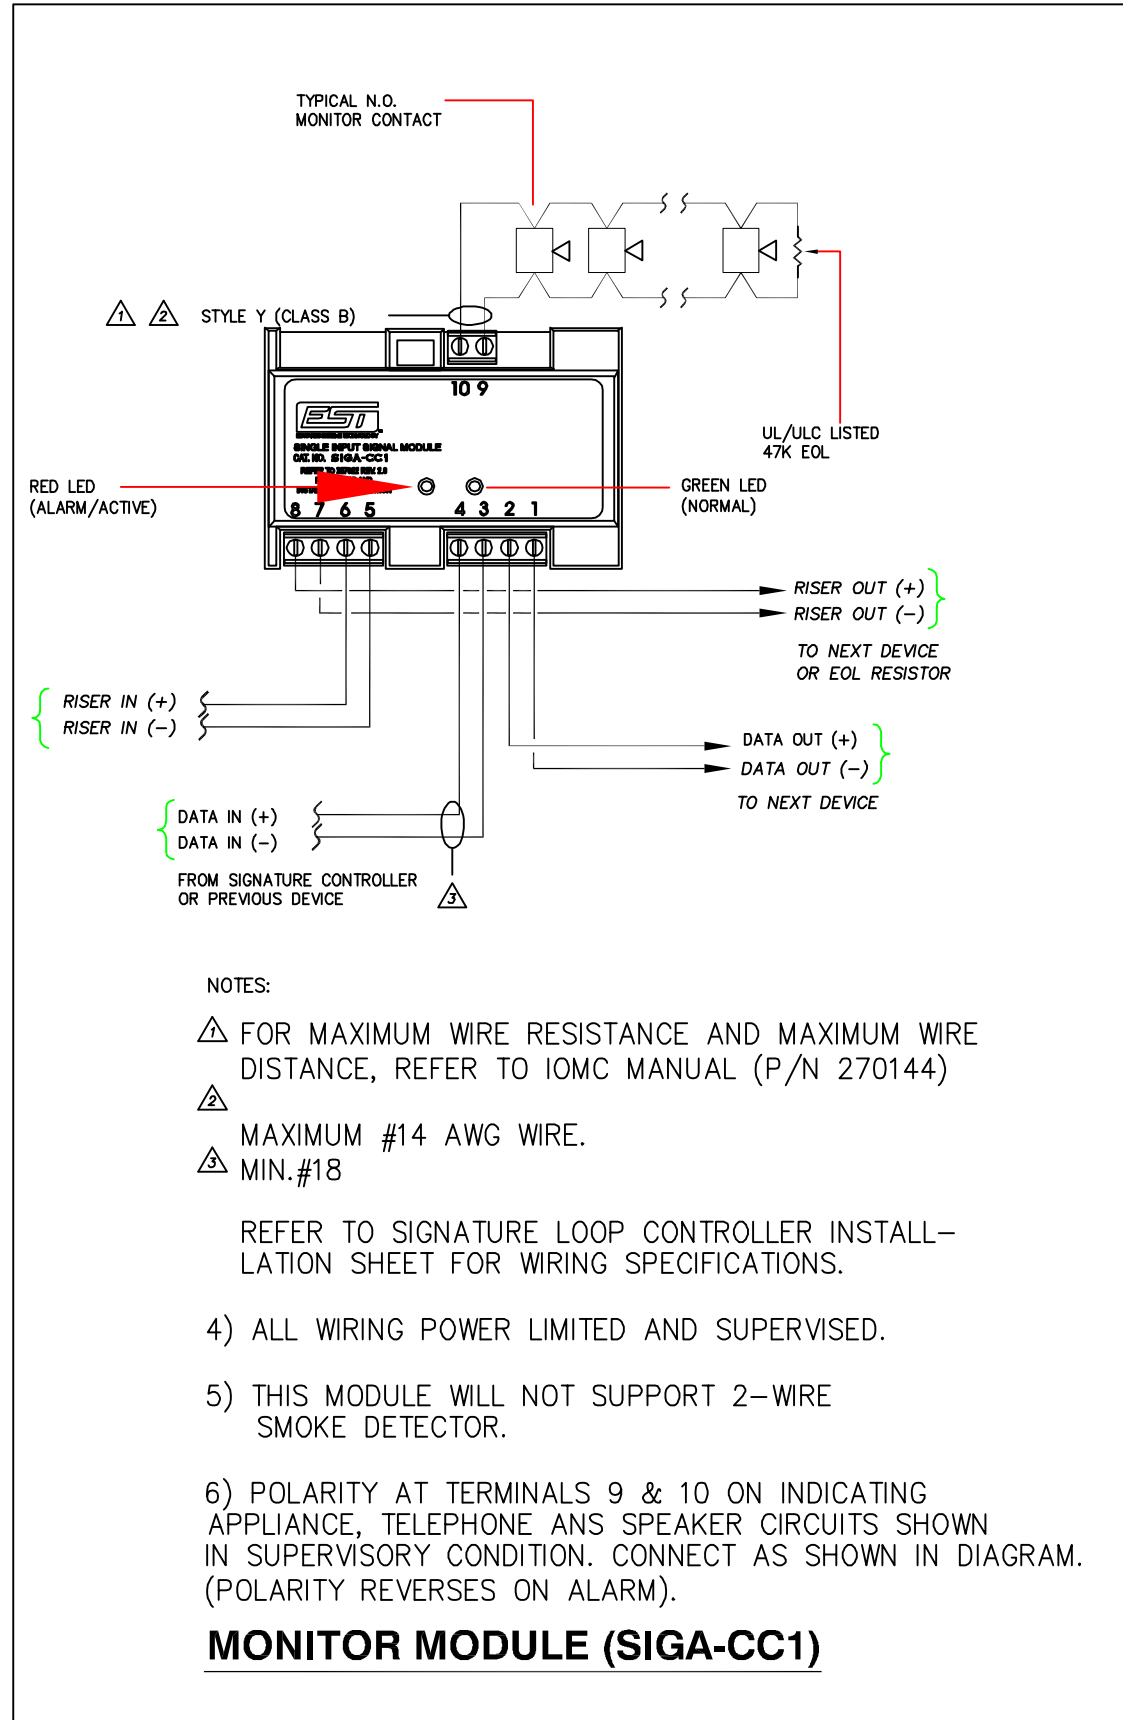
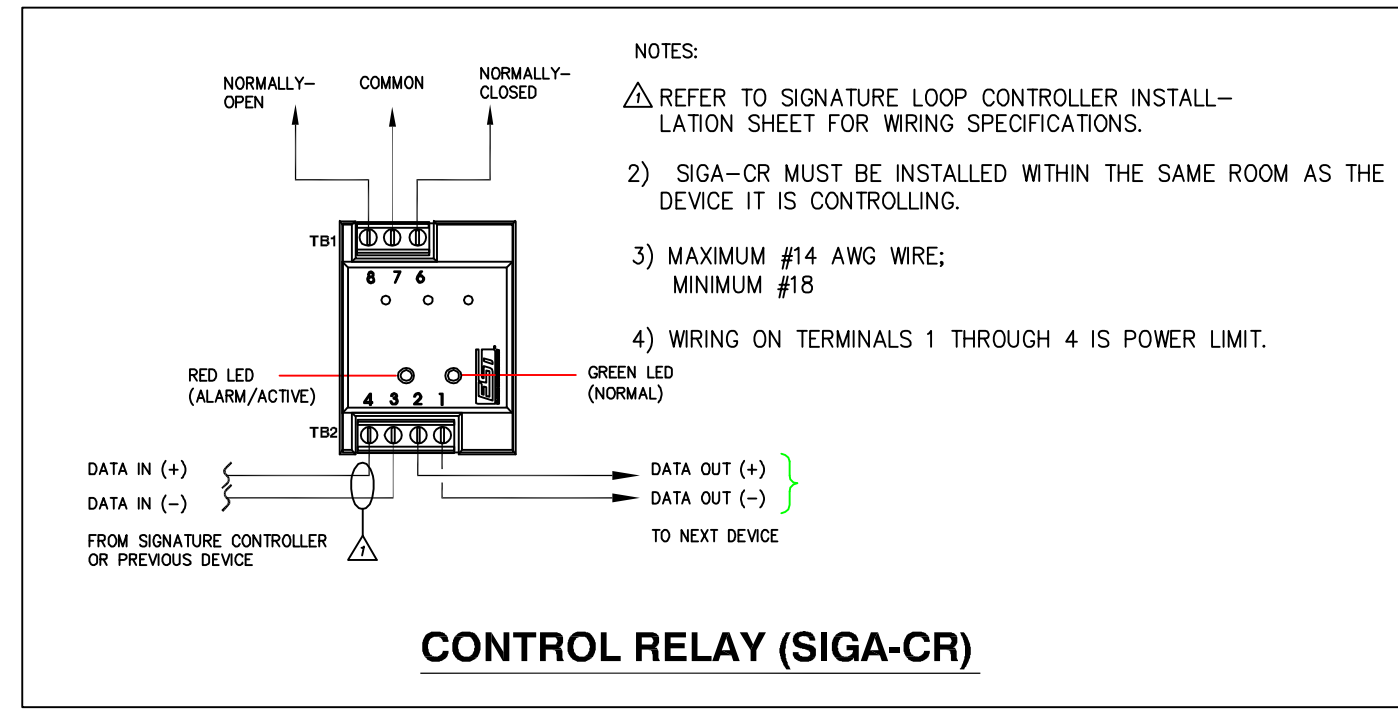
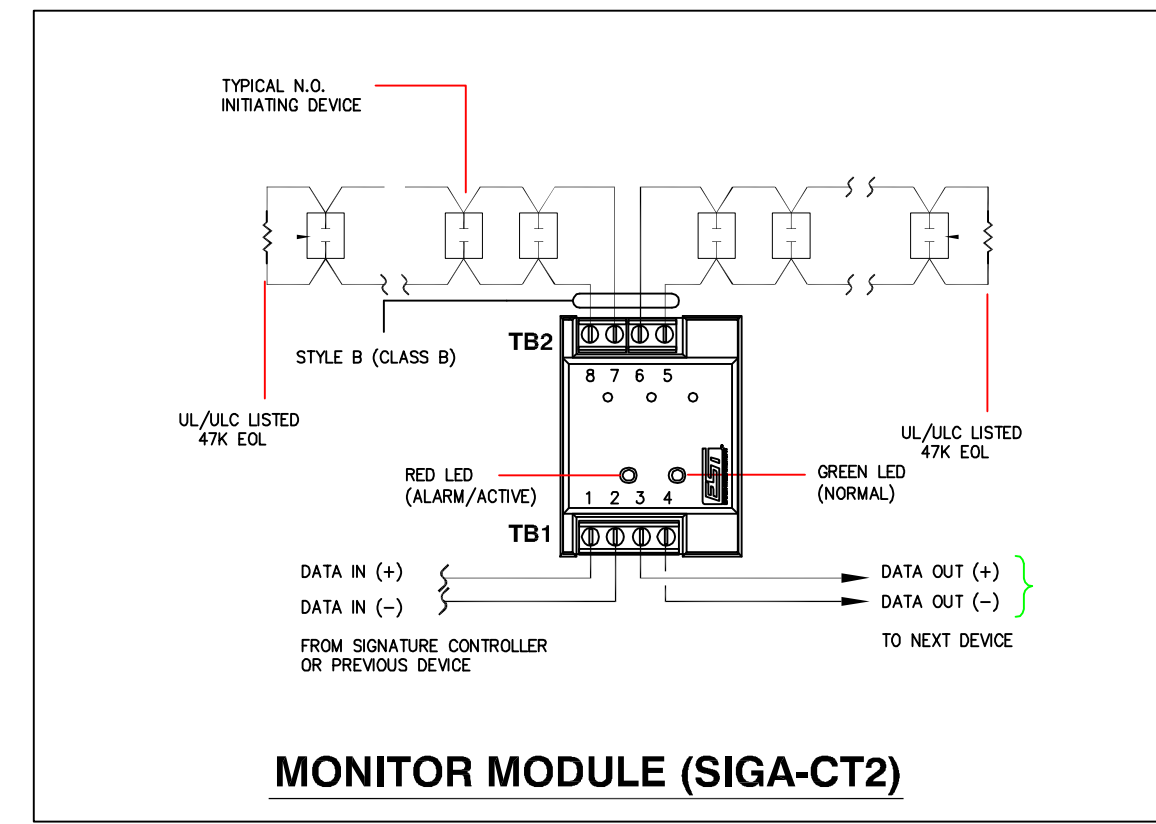


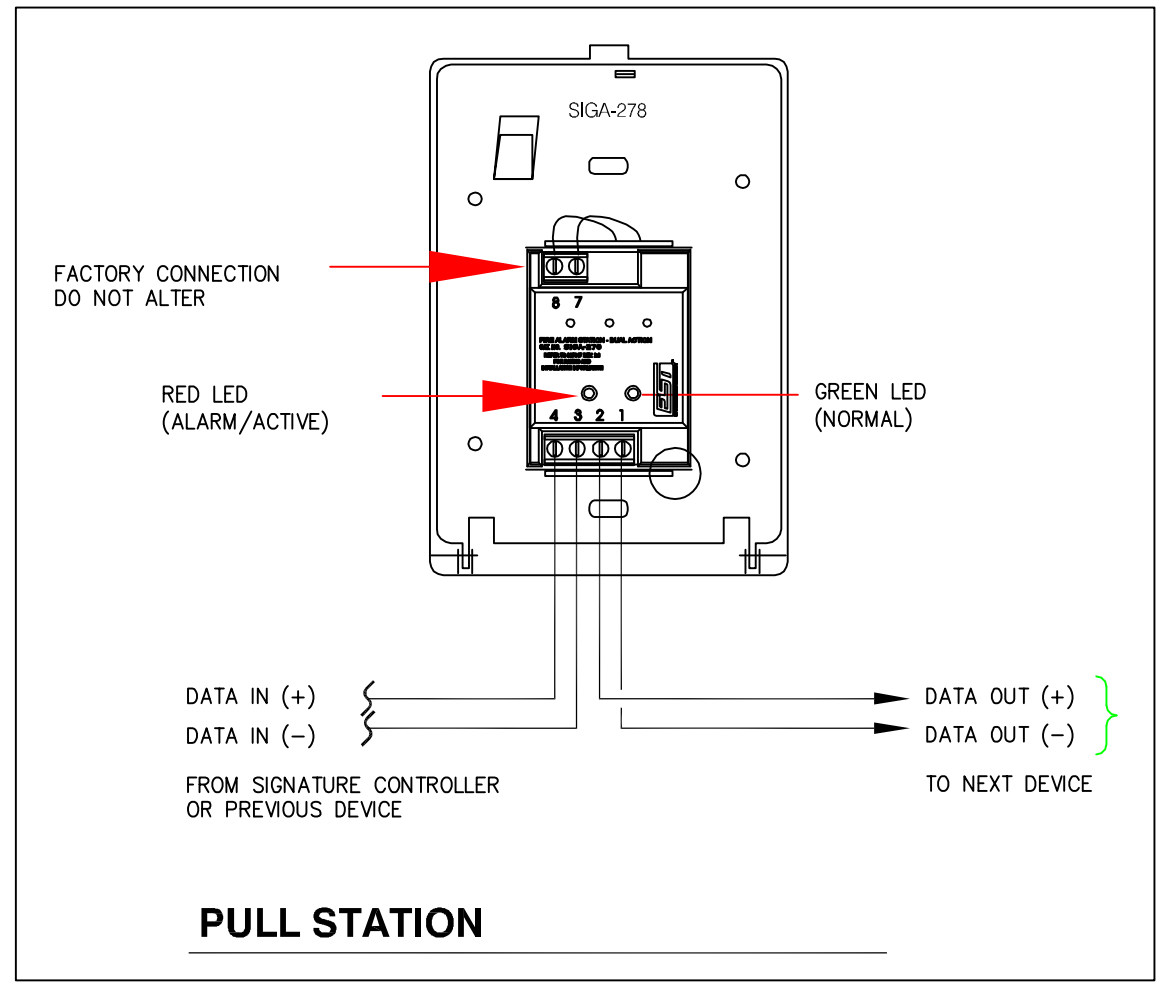

ANNUNCIATOR						
20223-20237 W. SATICOY STREET WINNETKA, CALIFORNIA 91306						
FLOOR	MANUAL PULL STATION	AREA SMOKE/HEAT DETECTOR	ELEVATOR LOBBY SMOKE DETECTOR	DUCT SMOKE DETECTOR	SPRINKLER WATER FLOW	SPRINKLER VALVE TAMPER
ROOF	Ⓡ	Ⓡ	Ⓡ	Ⓡ	Ⓡ	Ⓨ
4TH FLOOR	Ⓡ	Ⓡ	Ⓡ	Ⓡ	Ⓡ	Ⓨ
3RD FLOOR	Ⓡ	Ⓡ	Ⓡ	Ⓡ	Ⓡ	Ⓨ
2ND FLOOR	Ⓡ	Ⓡ	Ⓡ	Ⓡ	Ⓡ	Ⓨ
1st FLOOR	Ⓡ	Ⓡ	Ⓡ	Ⓡ	Ⓡ	Ⓨ
UPPER LEVEL GARAGE	Ⓡ	Ⓡ	Ⓡ	Ⓡ	Ⓡ	Ⓨ
LOWER LEVEL GARAGE	Ⓡ	Ⓡ	Ⓡ	Ⓡ	Ⓡ	Ⓨ
TROUBLE LAMP TEST A/C POWER						
	Ⓨ	Ⓞ	Ⓞ	Ⓞ	Ⓞ	Ⓞ

ALARM ENGINEERS
11145 TAMPA AVE. SUITE #24B
NORTH RIDGE, CA. 91326
TEL. (818) 831-5390 FAX. (818) 831-5391 LIC. # C10 867596

Project:
91 UNITS APARTMENT BUILDING
20223-20237 W. SATICOY STREET
WINNETKA, CALIFORNIA 91306

Revisions		
No.	Date	Description
1	5/5/06	FIRST RELEASE
2		
3		
4		
5		
6		
7		

Sheet Title:
**FIRE ALARM SYSTEM
GRAPHIC ANNUNCIATOR
& DETAILS**

Sheet Number:
FA-03