


FIRE ALARM RISER DIAGRAM

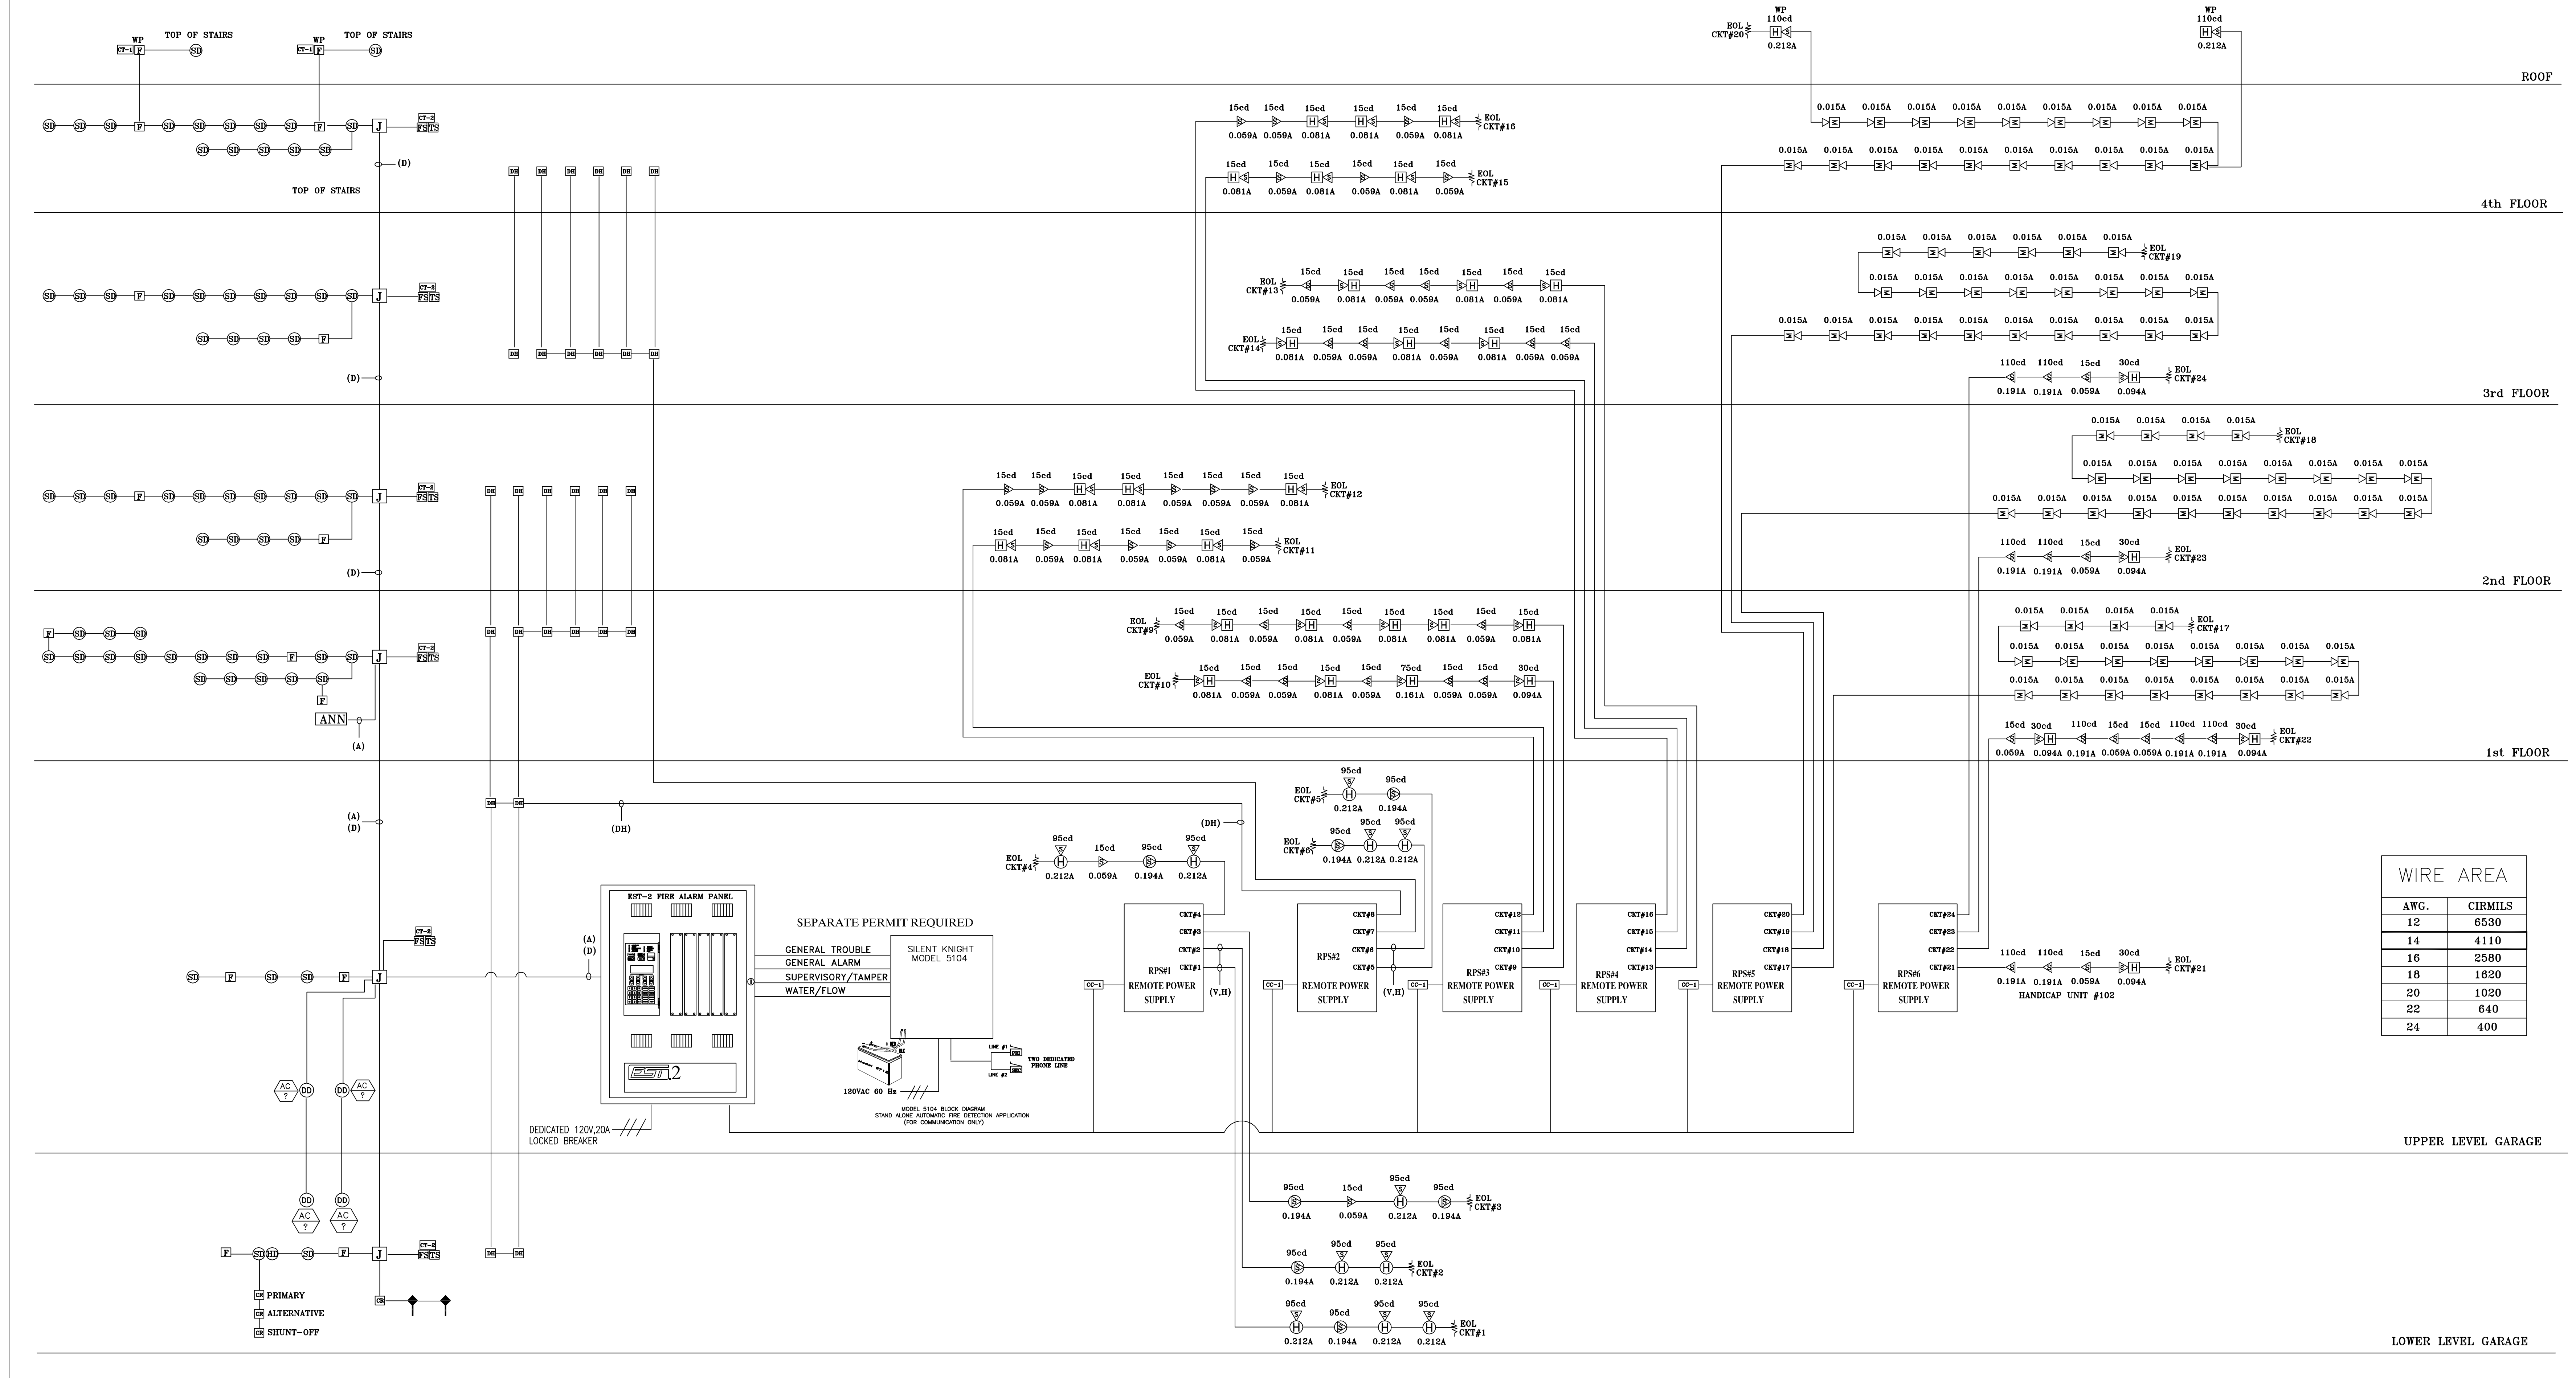

ALARM ENGINEERS
11145 TAMPA AVE. SUITE #24B
NORTH RIDGE, CA. 91326
TEL. (818) 831-5390 FAX. (818) 831-5391 LIC. # C10 867596

Project:
91 UNITS APARTMENT BUILDING
20223-20237 W. SATICOY STREET
WINNETKA, CALIFORNIA 91306

Revisions		
No.	Date	Description
1	5/5/06	FIRST RELEASE

Sheet Title: FIRE ALARM SYSTEM
RISER DIAGRAM

Sheet Number:
FA-04