


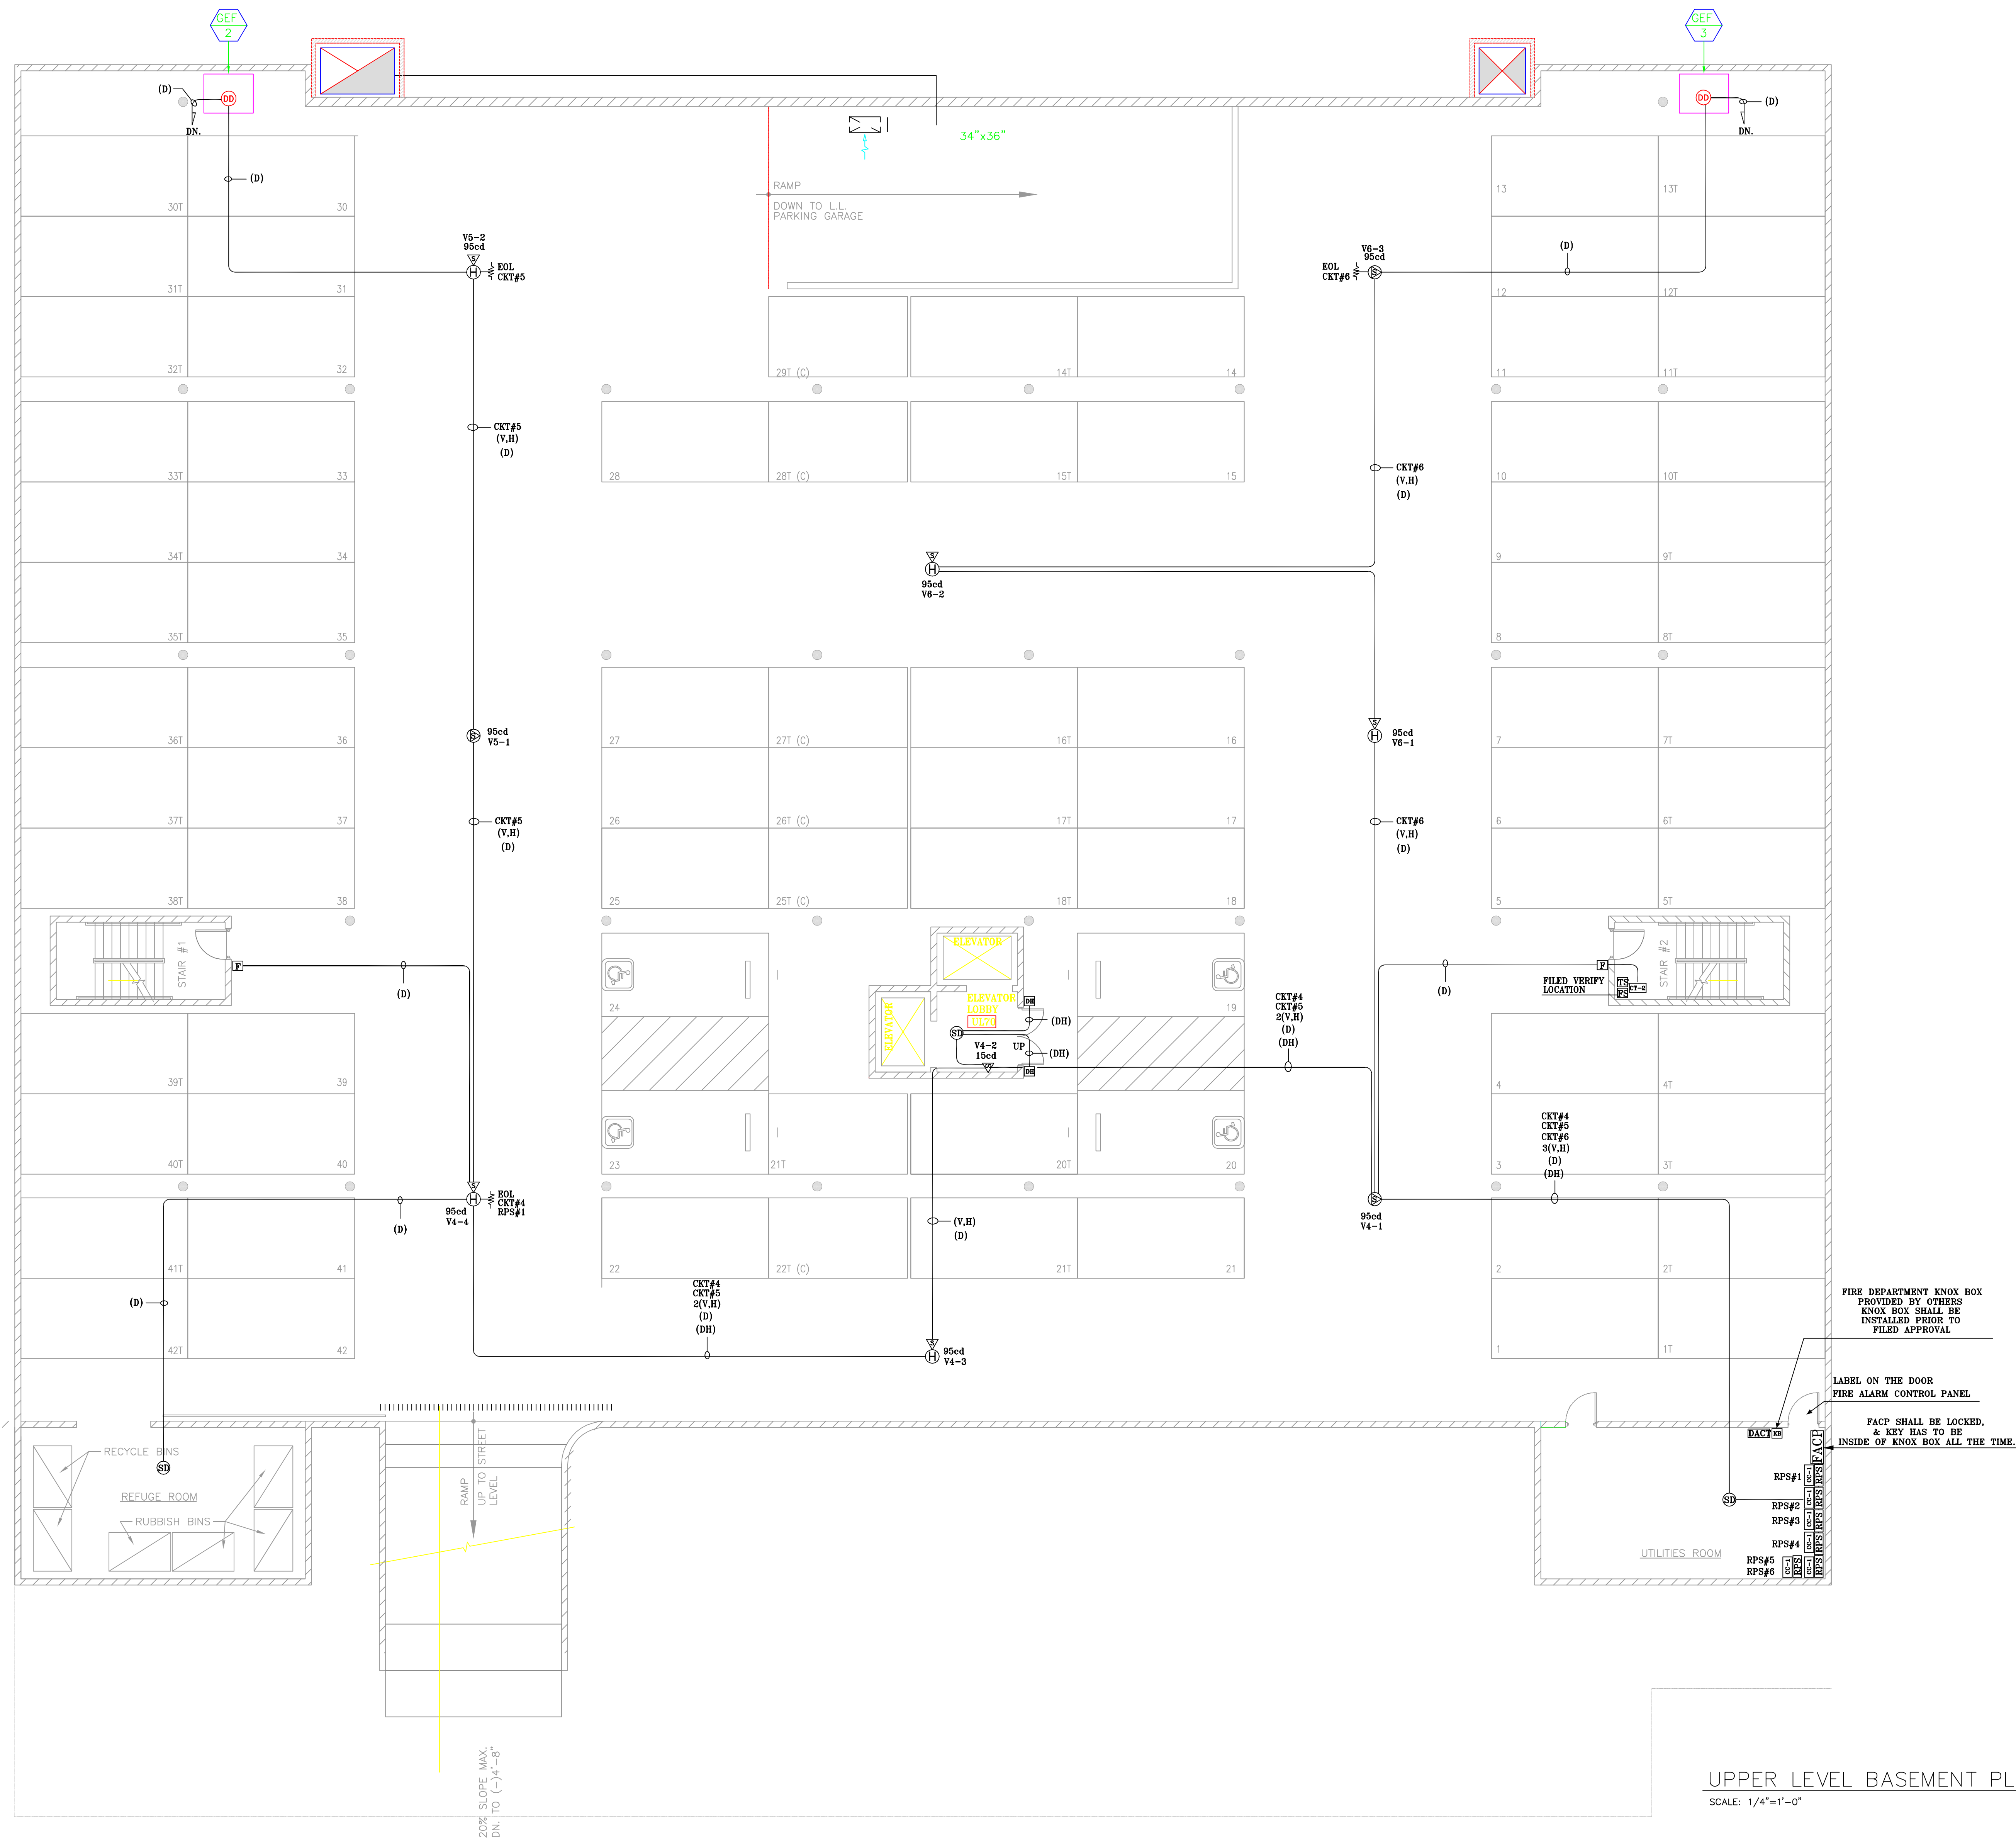

SYMBOL LIST	
SYMBOL	DESCRIPTION
[FACP]	FIRE ALARM CONTROL PANEL
[ANN]	GRAPHIC ANNUCIATOR
[RPS]	REMOTE POWER SUPPLY
[CC-1]	SIGNAL MODULE
[CT-2]	DUAL INPUT MODULE
[CM]	CONTROL MODULE
[P]	PULL STATION
[SD]	SMOKE DETECTOR
[HD]	HEAT DETECTOR
[DD]	DUCT SMOKE DETECTOR
[H-W]	HORN/STROBE (WALL)
[H-C]	HORN/STROBE (CEILING)
[S-W]	STROBE (WALL)
[S-C]	STROBE (CEILING)
[DH]	DOOR HOLDER
[FS]	FLOW SWITCH
[TS]	TAMPER SWITCH
[Y]	SMOKE FIRE DAMPER

WIRE LEGEND		
V.H	2#14 AWG.	VISIBLE CIRCUIT (STROBE) AUDIBLE CIRCUITS (HORN)
D	2#18 AWG.	ADDRESSABLE DATA CIRCUIT
A	2#18 AWG. 2#14 AWG.	ANNUNCIATOR
DH	2#14 AWG.	DOOR HOLDER

ALARM ENGINEERS
11145 TAMPA AVE. SUITE #24B
NORTH RIDGE, CA. 91326
TEL. (818) 831-5390 FAX. (818) 831-5391 LIC. # C10 867596

Project: **91 UNITS APARTMENT BUILDING**
20223-20237 W. SATICOY STREET
WINNETKA, CALIFORNIA 91306

Revisions		
No.	Date	Description
1	5/5/06	FIRST RELEASE

Sheet Title: **FIRE ALARM SYSTEM
UPPER LEVEL GARAGE**

Sheet Number: **FA-07**