


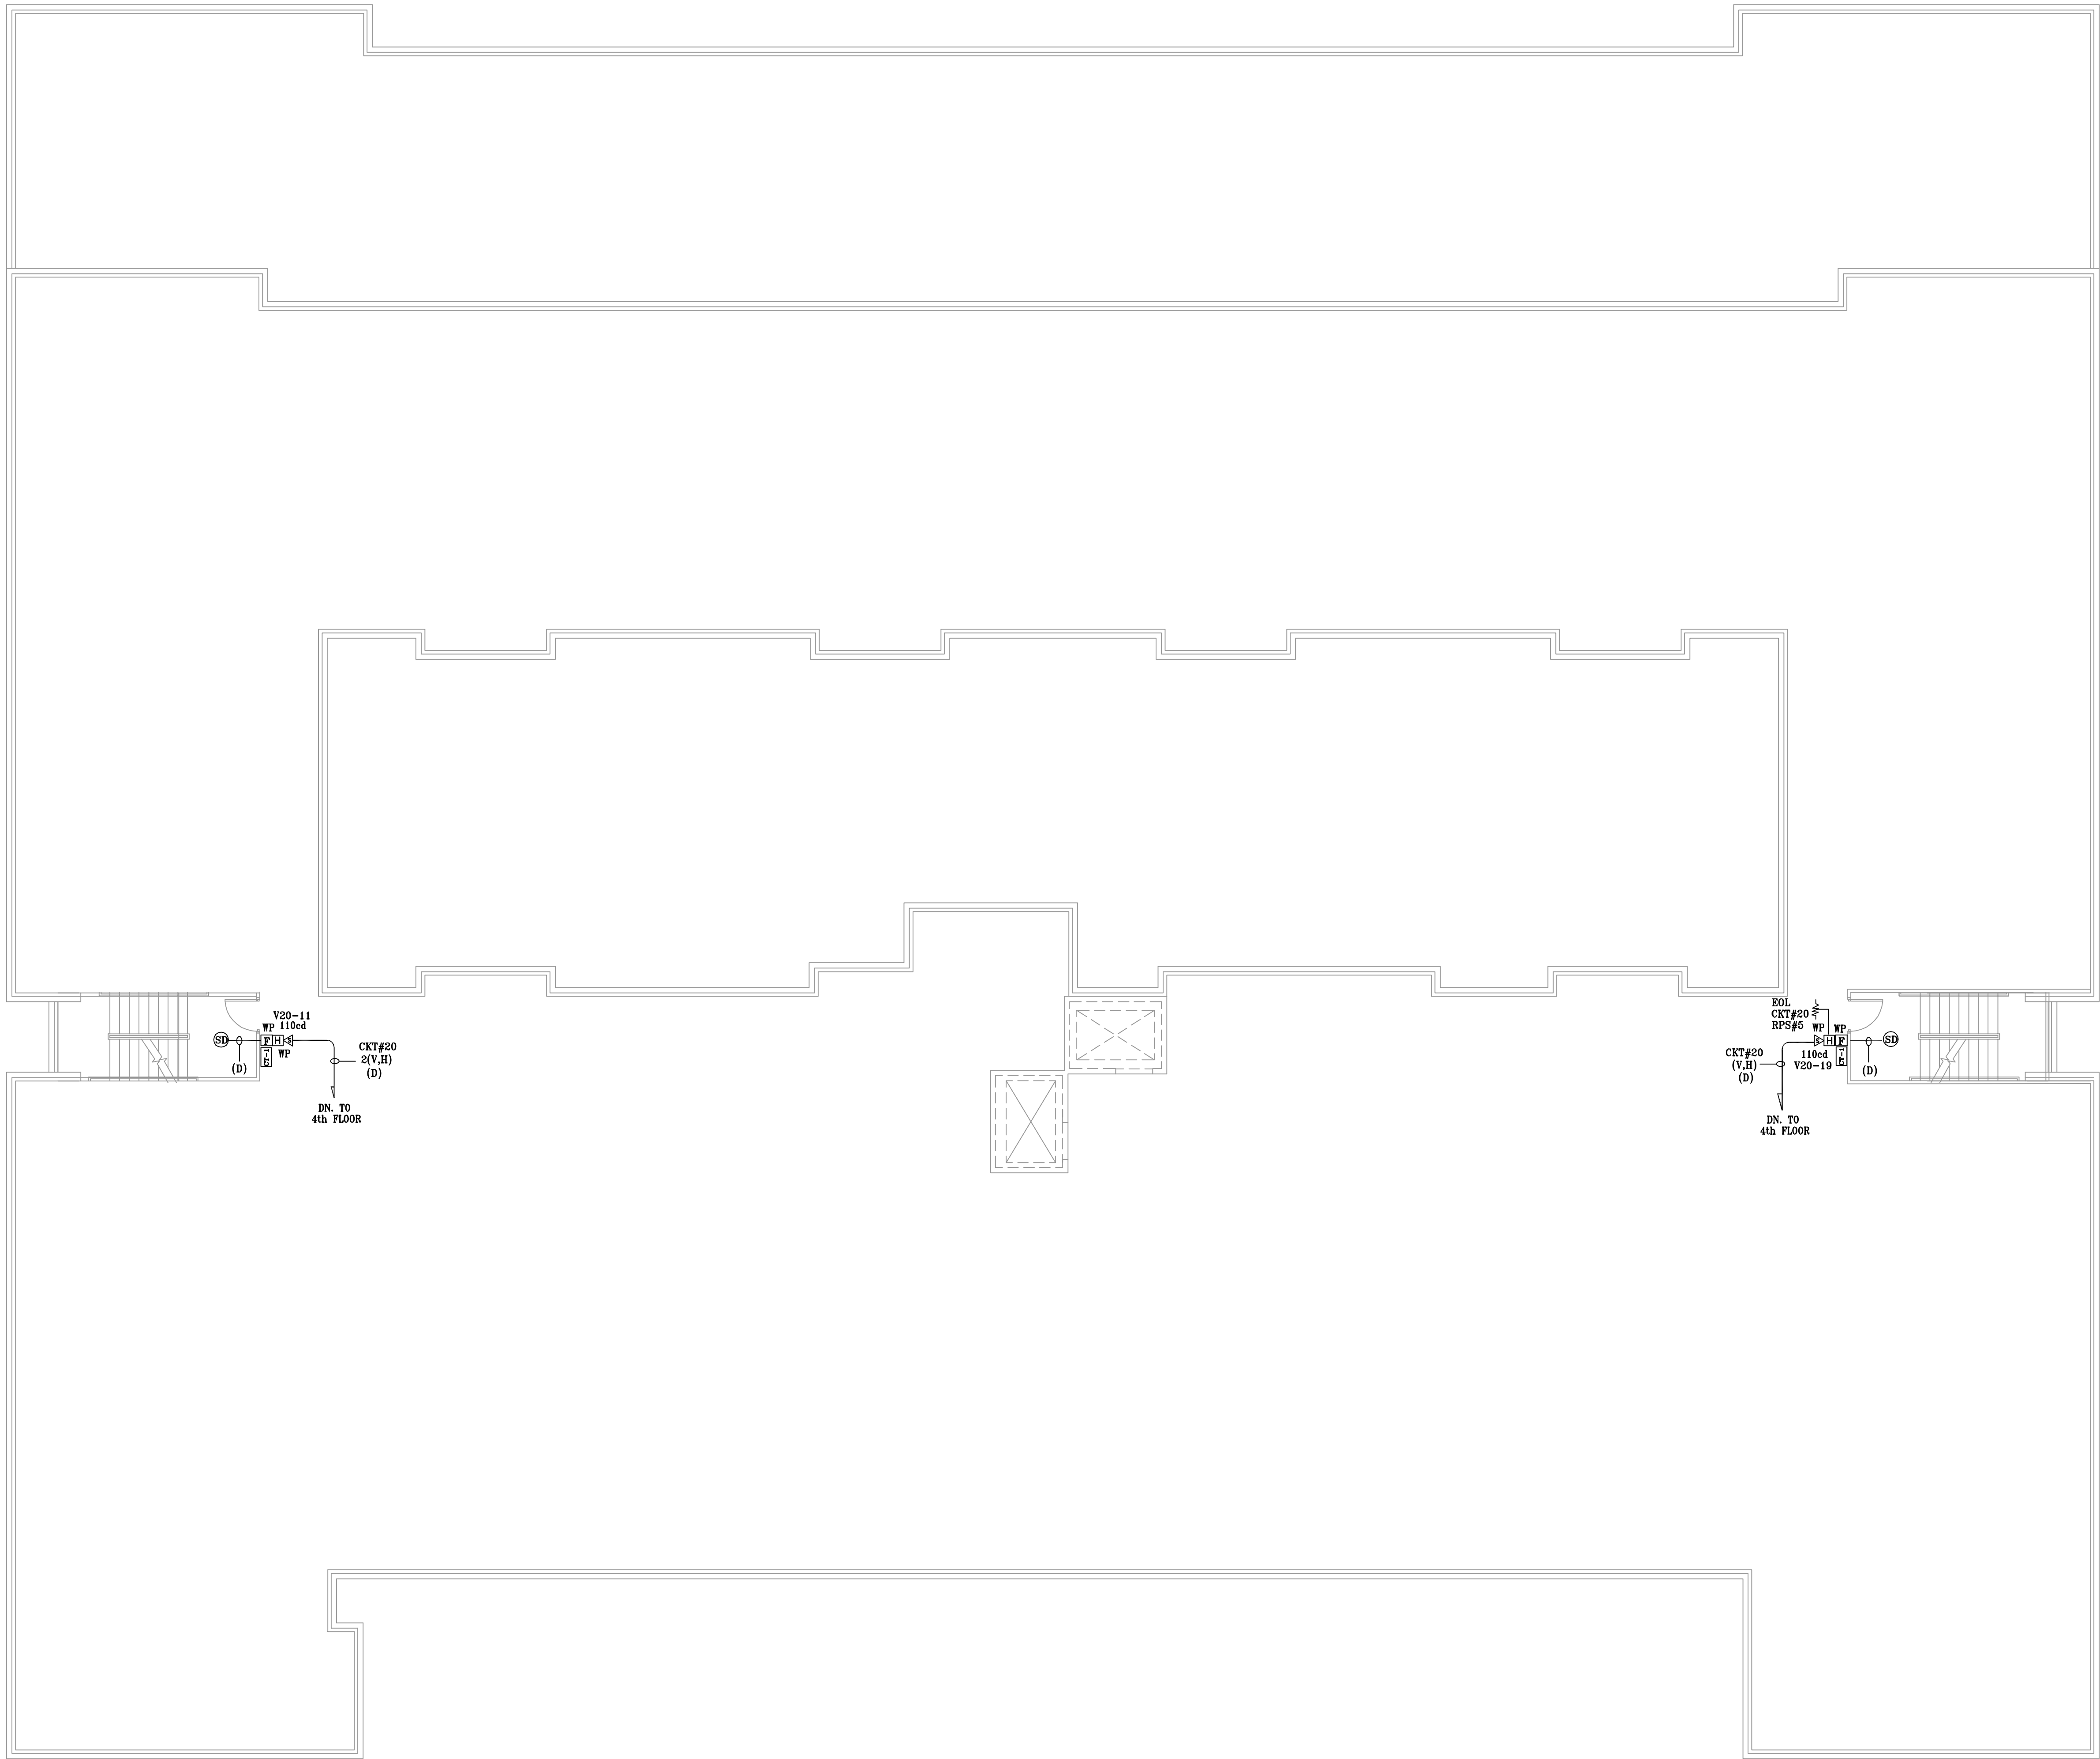

ROOF FLOOR PLAN
SCALE: 1/8"=1'-0"

SYMBOL LIST	
SYMBOL	DESCRIPTION
	FIRE ALARM CONTROL PANEL
	GRAPHIC ANNUCIATOR
	REMOTE POWER SUPPLY
	SIGNAL MODULE
	DUAL INPUT MODULE
	CONTROL MODULE
	PULL STATION
	SMOKE DETECTOR
	HEAT DETECTOR
	DUCT SMOKE DETECTOR
	HORN/STROBE (WALL)
	HORN/STROBE (CEILING)
	STROBE (WALL)
	STROBE (CEILING)
	DOOR HOLDER
	FLOW SWITCH
	TAMPER SWITCH
	SMOKE FIRE DAMPER

WIRE LEGEND		
V.H	2#14 AWG.	VISIBLE CIRCUIT (STROBE) AUDIBLE CIRCUITS (HORN)
D	2#18 AWG.	ADDRESSABLE DATA CIRCUIT
A	2#18 AWG. 2#14 AWG.	ANNUNCIATOR
DH	2#14 AWG.	DOOR HOLDER

ALARM ENGINEERS
11145 TAMPA AVE. SUITE #24B
NORTH RIDGE, CA. 91326
TEL. (818) 831-5390 FAX. (818) 831-5391 LIC. # C10 867596

Project: **91 UNITS APARTMENT BUILDING**
20223-20237 W. SATICOY STREET
WINNETKA, CALIFORNIA 91306

Revisions		
No.	Date	Description
	5/5/06	FIRST RELEASE

Sheet Title: **FIRE ALARM SYSTEM**
ROOF LEVEL

Sheet Number:

FA-12